
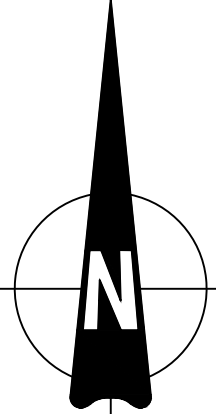


							SHEET INDEX <table><tr><td>Sheet No.</td><td>SHEET NAME</td></tr><tr><td>SP-1</td><td>SITE PLAN</td></tr><tr><td>A1</td><td>FLOOR PLAN</td></tr><tr><td>A2</td><td>ELECTRICAL PLAN</td></tr><tr><td>A3</td><td>ELEVATIONS - FRONT & BACK</td></tr><tr><td>A4</td><td>ELEVATIONS - RIGHT & LEFT</td></tr><tr><td>A5</td><td>ROOF PLAN / TRUSS LAYOUT</td></tr><tr><td>A6</td><td>SECTIONS</td></tr><tr><td>S1</td><td>FOUNDATION PLAN</td></tr><tr><td>S2</td><td>ROOF FRAMING</td></tr><tr><td>CS-1</td><td>MIN. CONSTRUCTION SPECIFICATIONS</td></tr></table>		Sheet No.	SHEET NAME	SP-1	SITE PLAN	A1	FLOOR PLAN	A2	ELECTRICAL PLAN	A3	ELEVATIONS - FRONT & BACK	A4	ELEVATIONS - RIGHT & LEFT	A5	ROOF PLAN / TRUSS LAYOUT	A6	SECTIONS	S1	FOUNDATION PLAN	S2	ROOF FRAMING	CS-1	MIN. CONSTRUCTION SPECIFICATIONS
							Sheet No.	SHEET NAME																						
							SP-1	SITE PLAN																						
							A1	FLOOR PLAN																						
							A2	ELECTRICAL PLAN																						
A3	ELEVATIONS - FRONT & BACK																													
A4	ELEVATIONS - RIGHT & LEFT																													
A5	ROOF PLAN / TRUSS LAYOUT																													
A6	SECTIONS																													
S1	FOUNDATION PLAN																													
S2	ROOF FRAMING																													
CS-1	MIN. CONSTRUCTION SPECIFICATIONS																													
GENERAL CODES THIS PROJECT SHALL COMPLY WITH THE FOLLOWING BUILDING CODES AND ASSOCIATED CITY OF TRACY ORDINANCES: -2022 CALIFORNIA RESIDENTIAL CODE -2022 CALIFORNIA BUILDING CODE -2022 CALIFORNIA GREEN BUILDING STANDARDS CODE -2022 CALIFORNIA ELECTRICAL CODE -2022 CALIFORNIA MECHANICAL CODE -2022 CALIFORNIA PLUMBING CODE -2022 CALIFORNIA FIRE CODE -2022 CALIFORNIA BUILDING ENERGY EFFICIENCY STANDARDS																														
DESIGN BASIS CONVENTIONAL LIGHT FRAME CONSTRUCTION ROOF LIVE LOAD: 20 PSF ULTIMATE WIND SPEED: 95 MPH EXPOSURE CATEGORY: C SITE CLASS: D RISK CATEGORY: II S_{pg}: 1.25 SEISMIC DESIGN CATEGORY: D_s ALLOW SOIL VERTICAL BEARING PRESSURE: 1500 PSF ALLOW SOIL LATERAL BEARING PRESSURE: 100 PSF/FT																														
By using these pre-approved plans for accessory dwelling unit construction design, the user agrees to release, hold harmless, and indemnify the City of Tracy and its elected officials, employees, and agents, including the Architect who prepared these construction documents, from any and all claims, liabilities, suits, and demands on account of any injury, damage or loss to persons or property, including injury or death, or economic losses, arising out of the use of these construction documents. The use of these plans does not eliminate or reduce the user's responsibility to verify any and all information.																														
																														
THESE PLANS ARE NOT APPROVED WHEN THE ADU IS LOCATED IN A WILDLAND URBAN INTERFACE (WUI) AREAS. 																														
VICINITY MAP	OWNER INFORMATION	CONTACT INFORMATION	PARCEL INFORMATION	PROJECT SCOPE	DEFERRED ITEMS LIST			SHEET TITLE																						
	NAME:	NAME:	APN:	PROPOSED 600 SF DETACHED ACCESSORY DWELLING UNIT	TRUSSES ENERGY ANALYSIS SOLAR PV SYSTEM GAS LINE DIAGRAM FIRE SPRINKLERS (IF NECESSARY)			SITE PLAN																						
	ADDRESS:	ADDRESS:	SITE ADDRESS:					SHEET NUMBER																						
	PHONE:	PHONE:	PROPERTY CONNECTED TO THE ELECTRICAL GRID (Y or N)	OPTIONAL ROLL-IN SHOWER SELECTED (Y OR N)				SP-1																						
	EMAIL:	EMAIL:	PRIMARY RESIDENCE PROTECTED BY AUTOMATIC FIRE SPRINKLER SYSTEM (Y or N)																											
			PROPERTY SERVICED BY NATURAL GAS (Y or N)																											

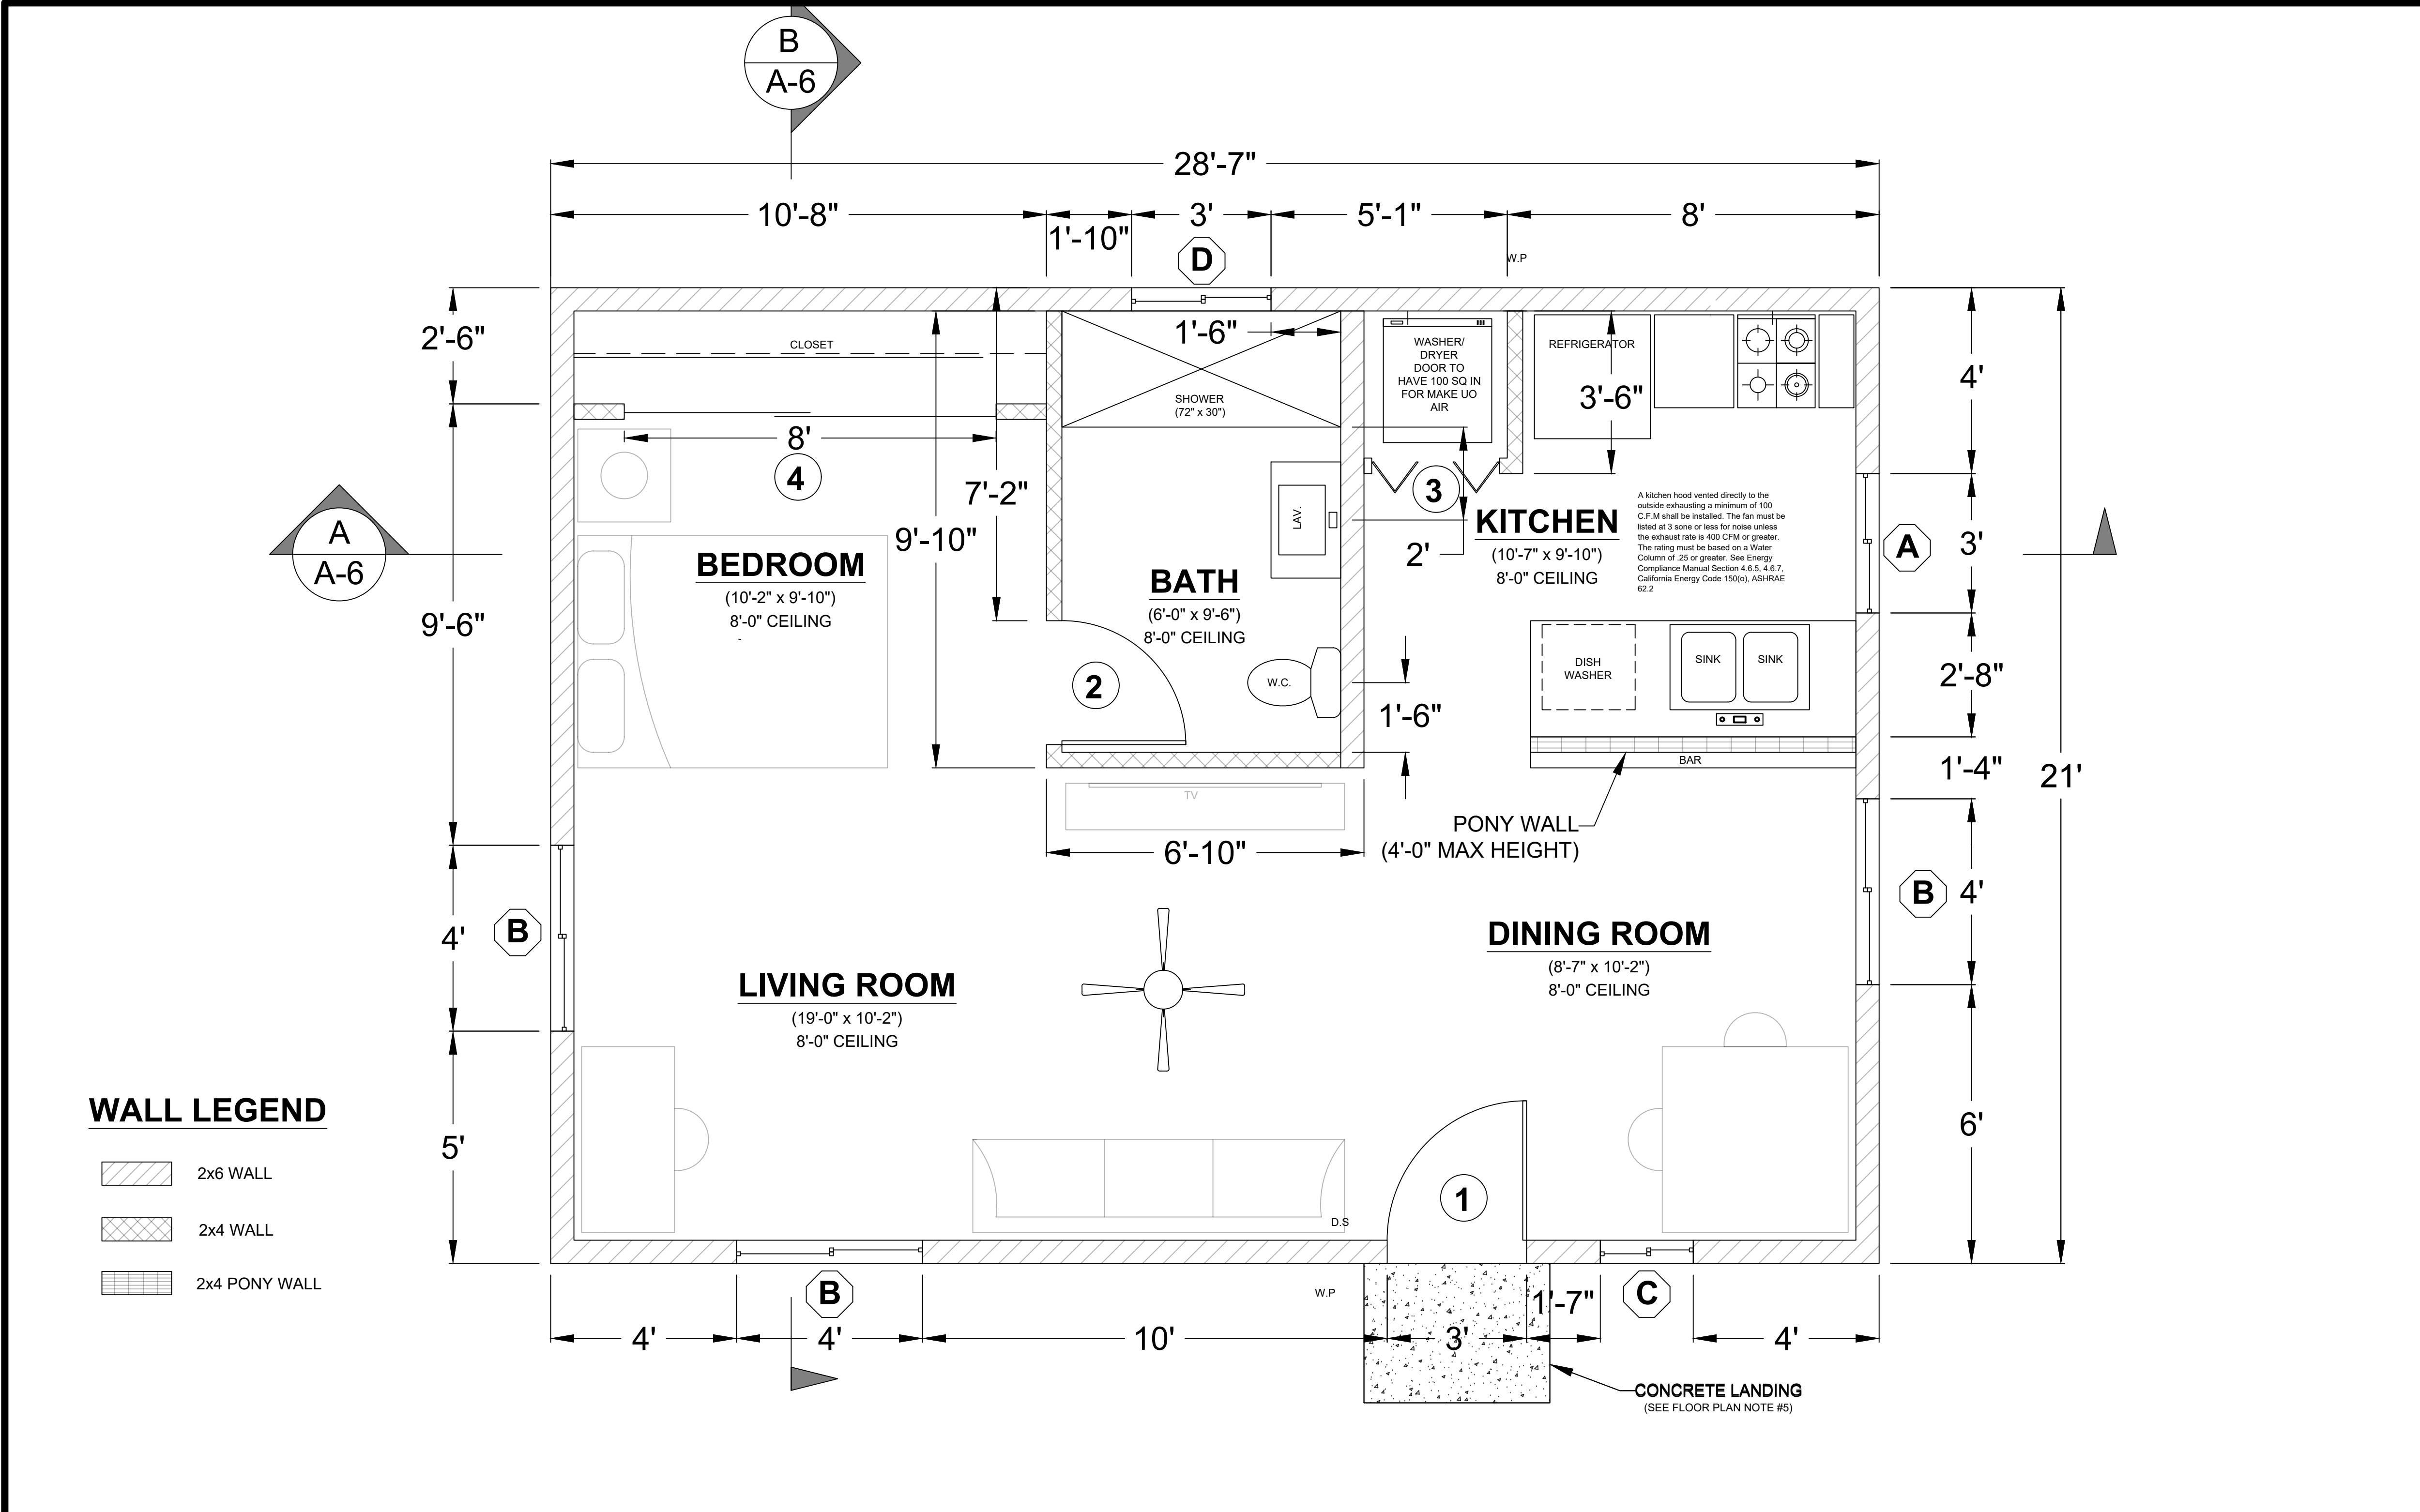

WALL LEGEND

- 2x6 WALL
- 2x4 WALL
- 2x4 PONY WALL

WINDOW SCHEDULE				
MARK	DIMENSION	TYPE	TEMPERED	NOTES
(A)	3'-0" x 4'-0"	SLIDING		
(B)	4'-0" x 4'-0"	SLIDING		
(C)	2'-0" x 3'-0"	SLIDING	Y	
(D)	3'-0" x 2'-0"	SLIDING	Y	

DOOR SCHEDULE				
MARK	DIMENSION	TYPE	TEMPERED	NOTES
(1)	3'-0" x 6'-8"	SWINGING		1-3/8" SOLID CORE
(2)	3'-0" x 6'-8"	SWINGING		
(3)		BI-FOLD		LAUNDRY ROOM
(4)	8'-0" x 6'-8"	SLIDING		6FT CLOSET

AGING IN PLACE NOTES

- At least one bathroom on the entry level shall be provided with reinforcement installed in accordance with this section. Where there is no bathroom on the entry level, at least one bathroom on the second or third floor of the dwelling shall comply with section R327.1.1.
 - Reinforcement shall be solid lumber or other construction materials approved by the enforcing agency.
 - Reinforcement shall not be less than 2 by 8 inch (51 mm by 203 mm) nominal lumber; [1 1/2 inch by 7 1/4 inch (38 mm by 184 mm) actual dimension] or other construction material providing equal height and load capacity. Reinforcement shall be located between 32 inches (812.8 mm) and 39 1/4 inches (997 mm) above the finished floor flush with the wall framing.
 - Water closet reinforcement shall be installed on both side walls of the fixture, or one side wall and the back wall.
 - Shower reinforcement shall be continuous where wall framing is provided.
 - Bathub and combination bathtub/shower reinforcement shall be continuous on each end of the bathtub and the back wall. Additionally, back wall reinforcement for a lower grab bar shall be provided with the bottom edge located no more than 6 inches (152.4 mm) above the bathtub rim.
 - Information and/or drawings identifying the location of grab bar reinforcement shall be placed in the operation and maintenance manual in accordance with the California Green Building Standards Code, Chapter 4, Division 4.4.
- Electrical receptacle outlets, switches and controls (including controls for heating, ventilation and air conditioning) intended to be used by occupants shall be located no more than 48 inches (1219.2 mm) measured from the top of the outlet box and not less than 15 inches (381 mm) measured from the bottom of the outlet box above the finish floor.
- Effective July 1, 2024, at least one bathroom and one bedroom on the entry level shall provide a doorway with a net clear opening of not less than 32 inches (812.8 mm), measured with the door positioned at an angle of 90 degrees from the closed position; or, in the case of a two- or three-story single family dwelling, on the second or third floor of the dwelling if a bathroom or bedroom is not located on the entry level.
- Doorbell buttons or controls, when installed, shall not exceed 48 inches (1219.2 mm) above exterior floor or landing, measured from the top of the doorbell button assembly. Where doorbell buttons integrated with other features are required to be installed above 48 inches (1219.2 mm) measured from the exterior floor or landing, a standard doorbell button or control shall also be provided at a height not exceeding 48 inches (1219.2 mm) above exterior floor or landing, measured from the top of the doorbell button or control.

FLOOR PLAN NOTES

- EXTERIOR WALLS WITHIN 3 FEET OF PROPERTY LINE (SPRINKLERS) OR 5 FEET OF PROPERTY LINE (WITHOUT SPRINKLERS) REQUIRE 1-HOUR FIRE RATING FOR EXPOSURE TO BOTH SIDES
- PROJECTIONS:
 - PROHIBITED WITHIN 2 FEET OF PROPERTY LINE
 - 1-HOUR FIRE RATING ON THE UNDERSIDE WITHIN 3FT OF PROPERTY LINE (SPRINKLERS)
 - 1-HOUR FIRE RATING ON THE UNDERSIDE WITHIN 5FT OF PROPERTY LINE (WITHOUT SPRINKLERS)
- OPENINGS:
 - PROHIBITED WITHIN 3FT OF PROPERTY LINE
 - MAXIMUM 25% OF WALL AREA WITHIN 5 FEET OF PROPERTY LINE (WITHOUT SPRINKLERS)
- PENETRATIONS:
 - 1-HOUR FIRE-RATED PENETRATIONS OF WALLS WITHIN 3FT OF PROPERTY LINE (SPRINKLERS)
 - 1-HOUR FIRE-RATED PENETRATIONS OF WALLS WITHIN 5FT OF PROPERTY LINE (WITHOUT SPRINKLERS)
- CONCRETE LANDING WITH MIN 36" DEPTH AND A MAXIMUM OF 1-1/2" LOWER THAN TOP OF DOOR THRESHOLD

OPTIONAL ROLL-IN SHOWER PLAN NOTES


OPTIONAL ROLL-IN SHOWER SELECTED (Y OR N)

- SHOWER COMPARTMENT SEAT
 - MUST BE FOLDING TYPE, NOT TO EXCEED MORE THAN 6 INCHES FROM MOUNTING WALL WHEN FOLDED
 - LOCATED WITHIN 27 INCHES OF SHOWER CONTROLS
 - MOUNTED MINIMUM 17 INCHES AND MAXIMUM 19 INCHES ABOVE BATHROOM FINISHED FLOOR
 - SEAT INSTALLED ON SIDE WALL ADJACENT TO CONTROLS AND EXTENDING FROM BACK WALL TO POINT WITHIN 3 INCHES OF SHOWER COMPARTMENT ENTRY
 - STRUCTURAL ADEQUACY OF MOUNTING HARDWARE AND FASTENERS TO ACCOMMODATE 250 POUND POINT LOAD APPLIED AT ANY POINT ON THE GRAB BAR, FASTENER, MOUNTING DEVICE, OR SUPPORTING STRUCTURE
- SHOWER GRAB BARS
 - MOUNTED MINIMUM 33 INCHES AND MAXIMUM 36 INCHES ABOVE SHOWER FLOOR
 - NOT EXTENDING OVER SHOWER SEAT
 - IF CROSS SECTION IS CIRCULAR, MINIMUM 1-1/4" AND MAXIMUM 2" OUTSIDE DIAMETER
 - IF CROSS SECTION IS NON-CIRCULAR, MINIMUM 4" AND MAXIMUM 4.8" PERIMETER AND MAXIMUM 2-1/4" CROSS SECTION DIMENSION
 - GRAB BARS MOUNTED ADJACENT TO A WALL, 1-1/2" ABSOLUTE SPACE BETWEEN WALL AND GRAB BAR
 - MINIMUM 1-1/2" SPACE BETWEEN GRAB BAR AND PROJECTING OBJECTS BELOW AND AT ENDS
 - MINIMUM 12 INCH SPACE BETWEEN GRAB BAR AND PROJECTING OBJECTS ABOVE
 - SURFACE MATERIAL OF ANY WALLS OR OBJECTS ADJACENT TO GRAB BARS MUST BE FREE OF SHARP OR ABRASIVE ELEMENTS AND HAVE ROUNDED EDGES
 - STRUCTURAL ADEQUACY OF MOUNTING HARDWARE AND FASTENERS TO ACCOMMODATE 250 POUND POINT LOAD APPLIED AT ANY POINT ON THE GRAB BAR, FASTENER, MOUNTING DEVICE, OR SUPPORTING STRUCTURE
 - WALL REINFORCEMENT TO BE PROVIDED AT LOCATION OF GRAB BARS (E.G. BLOCKING)
- OPERABLE PARTS OF SHOWER CONTROLS AND FAUCETS:
 - INSTALLED ON BACK WALL OF SHOWER COMPARTMENT ADJACENT TO SEAT WALL
 - LOCATED MINIMUM 19 INCHES AND MAXIMUM 27 INCHES FROM SEAT WALL
 - LOCATED ABOVE GRAB BAR BUT NO HIGHER THAN 48 INCHES ABOVE SHOWER FLOOR
 - CENTERLINE AT MINIMUM 39 INCHES AND MAXIMUM 41 INCHES ABOVE SHOWER FLOOR
 - SINGLE-LEVER DESIGN
 - OPERABLE WITH MAXIMUM 5 POUNDS OF FORCE
 - OPERABLE WITH ONE HAND AND WITHOUT TIGHT GRASPING, PINCHING, OR TWISTING OF WRIST
- SPRAYER UNIT AND ASSOCIATED OPERABLE PARTS SHALL BE PROVIDED PER THE FOLLOWING:
 - OPERABLE PARTS, INCLUDING HANDLE, TO BE INSTALLED ON BACK WALL OF SHOWER COMPARTMENT MINIMUM 19 INCHES AND MAXIMUM 27 INCHES FROM SEAT WALL
 - OPERABLE PARTS LOCATED ABOVE GRAB BAR BUT NO HIGHER THAN 48 INCHES ABOVE SHOWER FLOOR, MEASURED TO TOP OF MOUNTING BRACKET
 - MINIMUM 59 INCH LONG HOSE
 - CAPABLE FOR USE AS FIXED SHOWER HEAD AND HAND HELD SHOWER
 - ON/OFF CONTROL WITH NON-POSITIVE SHUT OFF
 - ADJUSTABLE -HEIGHT SHOWER HEADS ON VERTICAL BAR SHALL NOT OBSTRUCT USE OF BATHTUB GRAB BARS
- WHERE SOAP DISHES ARE PROVIDED, MAXIMUM 40 INCHES ABOVE SHOWER FLOOR AND WITHIN REACH LIMITS FROM THE SHOWER SEAT
- MAXIMUM 2.1% SLOPE IN ALL DIRECTIONS OF ROLL-IN SHOWER FLOORS
- MAXIMUM 1/4" HIGH THRESHOLDS WITH MAXIMUM 50% BEVELED SLOPE AT ROLL-IN SHOWERS
- WHERE DRAINS ARE PROVIDED AT ROLL-IN SHOWERS, MAXIMUM 1/4" GRATE OPENINGS FLUSH WITH SHOWER FLOOR SURFACE

By using these pre-approved plans for accessory dwelling unit construction design, the user agrees to release, hold harmless, and indemnify the City of Tracy and its elected officials, employees, and agents, including the Architect who prepared these construction documents, from any and all claims, liabilities, suits, and demands on account of any injury, damage or loss to persons or property, including injury or death, or economic losses, arising out of the use of these construction documents. The use of these plans does not eliminate or reduce the user's responsibility to verify any and all information.

600 SF ACCESSORY DWELLING UNIT

Sheet Number

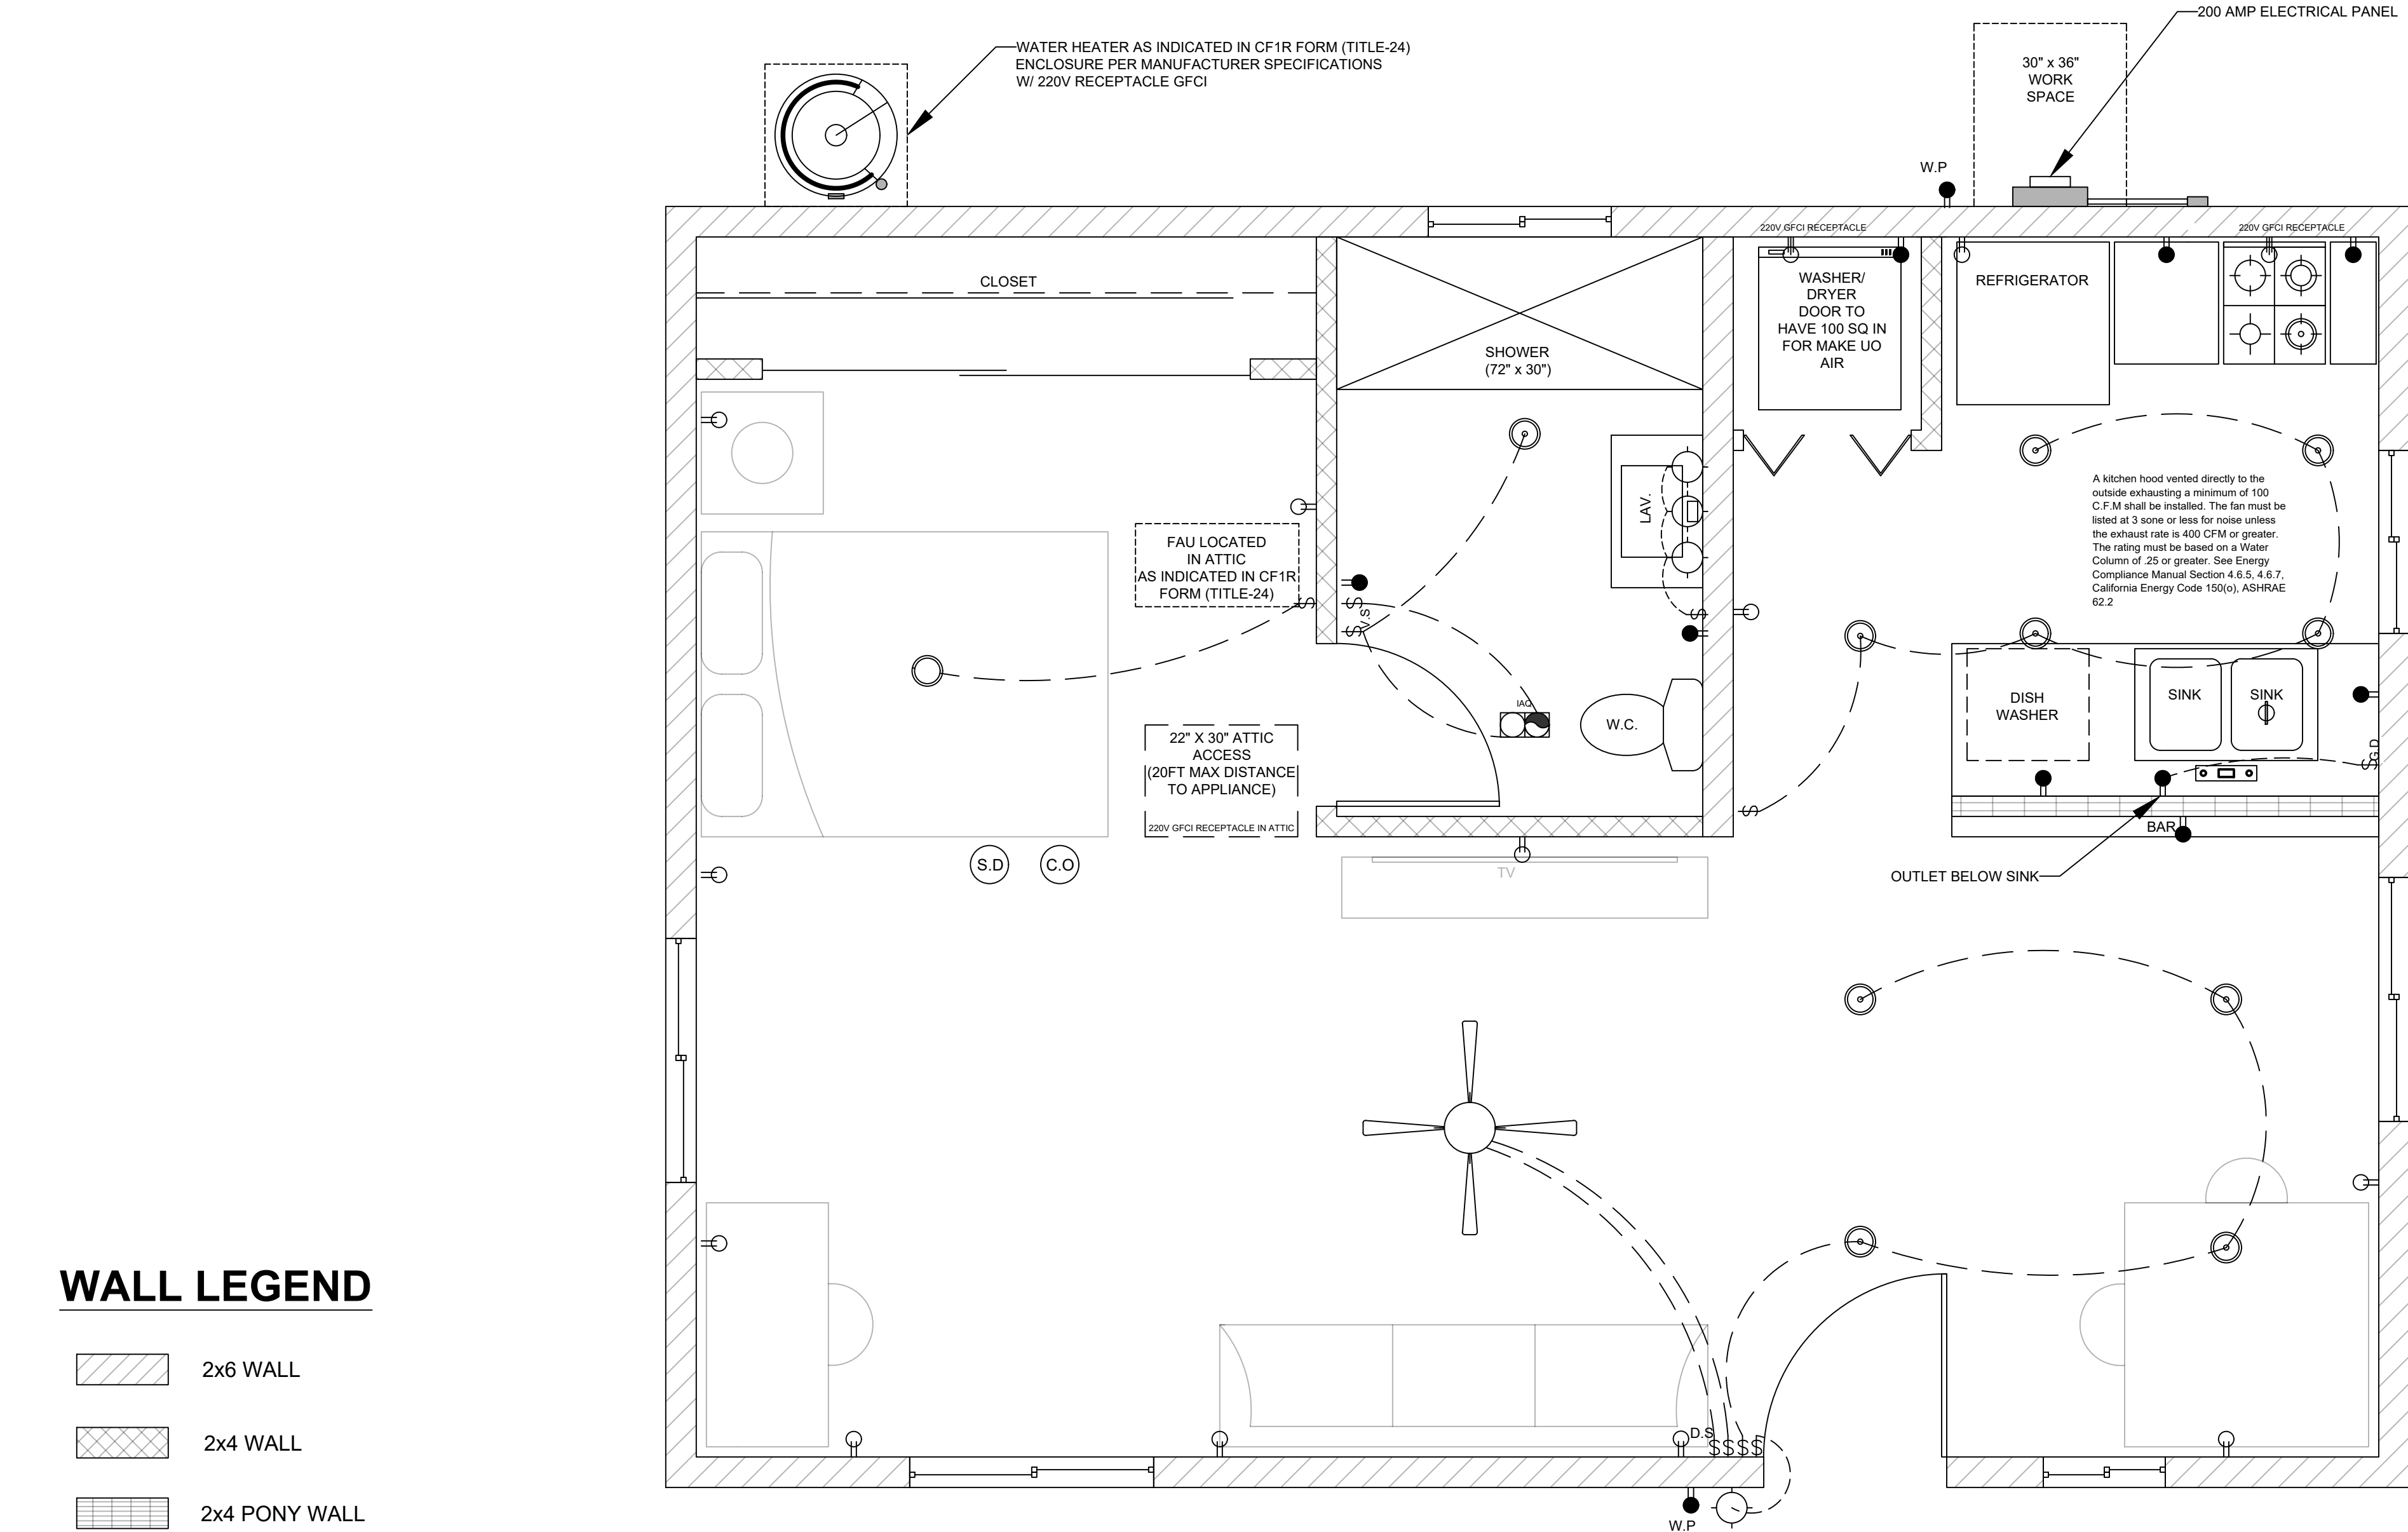

WALL LEGEND

- 2x6 WALL
- 2x4 WALL
- 2x4 PONY WALL

ELECTRICAL LEGEND

DUPLEX OUTLET	HIGH EFFICACY RECESSED LIGHT
WALL SWITCH	GARBAGE DISPOSAL
GARBAGE DISPOSAL SWITCH	DUPLEX OUTLET W/ GFCI
VACANCY SENSOR	DUPLEX OUTLET W/ GFCI & WATER PROOF
4" DIA DRYER VENT	
SMOKE DETECTOR	FAN & LIGHT COMBO
CARBON MONOXIDE ALARM	
FAN AND LIGHT COMBINATION	
HIGH EFFICACY LIGHT FIXTURE	

UTILITY PLAN NOTES

- If a new service is installed, a surge-protective device is required (SPD). The SPD shall be an integral part of the service equipment or shall be located immediately adjacent thereto. The SFP shall be a Type 1 or Type 2. CEC 230.67
- LOCAL EXHAUST FANS TO EXTERIOR TO PROVIDE MINIMUM 50 CFM INTERMITTENT OR 20 CFM CONTINUOUS VENTILATION.
- SMOKE DETECTORS TO BE INTERCONNECTED PER CRC R314.4 AND HARD-WIRED WITH BATTERY BACK-UP PER CRC R314.6
- CARBON MONOXIDE ALARMS TO BE INTERCONNECTED PER CRC R315.7 AND HARD-WIRED WITH BATTERY BACK-UP PER CRC R315.5
- 4" Ø DRYER VENT WITH MAXIMUM 14 FOOT COMBINED HORIZONTAL AND VERTICAL LENGTH WITH TWO 90 DEGREE ELBOWS.
- A MECHANICAL EXHAUST VENTILATION SYSTEM, SUPPLY VENTILATION SYSTEM, OR COMBINATION THEREOF SHALL BE INSTALLED FOR EACH DWELLING UNIT TO PROVIDE WHOLE-BUILDING VENTILATION WITH OUTDOOR AIR IN COMPLIANCE WITH ASHRAE STANDARD 62.2 AS ADOPTED BY THE CALIFORNIA ENERGY COMMISSION.
- AN INTERMITTENTLY OR CONTINUOUSLY OPERATING LOCAL MECHANICAL EXHAUST VENTILATION SYSTEM SHALL BE INSTALLED IN EACH BATHROOM WITH A BATHTUB, SHOWER, OR SIMILAR MOISTURE SOURCE AND IN EACH KITCHEN IN COMPLIANCE WITH ASHRAE STANDARD 62.2 AS ADOPTED BY THE CALIFORNIA ENERGY COMMISSION. INTERMITTENT LOCAL EXHAUST VENTILATION AIRFLOW RATES SHALL BE 50 CFM IN BATHROOMS AND 100 CFM IN KITCHENS. CONTINUOUS LOCAL EXHAUST VENTILATION AIRFLOW RATES SHALL BE 20 CFM IN BATHROOMS AND 5 AIR CHANGES PER HOUR IN KITCHENS BASED ON KITCHEN VOLUME.
- WATER HEATER OR FURNACE SHALL BE A DIRECT-VENT APPLIANCE
- LISTED GASKETED SELF CLOSING DOOR REQUIRED FOR GAS FAU
- PROVIDE HEATING/AC APPLIANCE FOR ALL HABITABLE AREAS PER CALIFORNIA RESIDENTIAL CODE R303.10.
- WHERE HEATING/AC APPLIANCE IS INSTALLED IN ATTIC AREA:
 - RECEPTACLE OUTLET SHALL BE INSTALLED ON SAME LEVEL AND WITHIN 25 FT OF EQUIPMENT. RECEPTACLE OUTLET SHALL NOT BE CONNECTED TO THE LOAD SIDE OF THE EQUIPMENT DISCONNECTING MEANS.
 - ACCESS, PASSAGEWAY CLEARANCE, AND WORK PLATFORM SHALL BE PROVIDED PER CALIFORNIA MECHANICAL CODE 304.4


LIGHTING PLAN NOTES

- ALL LUMINAIRES SHALL BE HIGH-EFFICACY IN ACCORDANCE WITH CEnC TABLE 150.0-A
- ALL LED LUMINAIRES AND LAMPS SHALL BE MARKED "JA8-2016" AND LISTED IN THE CALIFORNIA ENERGY COMMISSION DATABASE AT [HTTPS://CACERTAPPLIANCES.ENERGY.CA.GOV/PAGES/ APPLIANCESEARCH.ASPX](https://cacertappliances.energy.ca.gov/pages/appliancesearch.aspx)
- ALL RECESSED DOWNLIGHT AND ENCLOSED LUMINAIRES SHALL BE MARKED "JA8-2016-E" AND LISTED IN THE CALIFORNIA ENERGY COMMISSION DATABASE AT [HTTPS://CACERTAPPLIANCES.ENERGY.CA.GOV/PAGES/ APPLIANCESEARCH.ASPX](https://cacertappliances.energy.ca.gov/pages/appliancesearch.aspx)
- RECESSED DOWNLIGHT LUMINAIRES IN CEILINGS SHALL NOT BE SCREW-BASED
- BATHROOMS, GARAGES, LAUNDRY ROOMS, AND UTILITY ROOMS: AT LEAST ONE LUMINAIRE IN EACH SPACE SHALL BE CONTROLLED BY A VACANCY SENSOR
- ALL LUMINAIRES REQUIRING "JA8-2016" OR "JA8-2016-E" MARKING SHALL BE CONTROLLED BY A DIMMER OR VACANCY SENSOR
EXCEPTION: CLOSETS LESS THAN 70 S.F. & HALLWAYS
- OUTDOOR LIGHTING PERMANENTLY MOUNTED TO BUILDINGS SHALL BE CONTROLLED BY ONE OF THE FOLLOWING:
 - PHOTOCONTROL AND MOTION SENSOR
 - PHOTOCONTROL AND AUTOMATIC TIME-SWITCH CONTROL
 - ASTRONOMICAL TIME CLOCK
 - ENERGY MANAGEMENT CONTROL SYSTEM PER CEnC 150.0(K)3AIIIC
- ALL NEW OUTLET RECEPTACLES SHALL BE LISTED TAMPER-RESISTANT RECEPTACLES. [CEC Art. 406.12]
- OPTIONAL 240-VOLT RECEPTACLE OUTLET MAY BE INSTALLED FOR PROPOSED ELECTRIC DRYER OR ELECTRIC RANGE ON A DEDICATED BRANCH CIRCUIT.
- INSTALL LIGHTING OUTLET IN ATTIC AREA AND SWITCH AT POINT OF ENTRY TO THE ATTIC AREA. WHERE MECHANICAL HVAC UNIT IS INSTALLED IN ATTIC AREA LIGHTING OUTLET SHALL BE INSTALLED NEAR EQUIPMENT.


By using these pre-approved plans for accessory dwelling unit construction design, the user agrees to release, hold harmless, and indemnify the City of Tracy and its elected officials, employees, and agents, including the Architect who prepared these construction documents, from any and all claims, liabilities, suits, and demands on account of any injury, damage or loss to persons or property, including injury or death, or economic losses, arising out of the use of these construction documents. The use of these plans does not eliminate or reduce the user's responsibility to verify any and all information.

600 SF ACCESSORY DWELLING UNIT

Sheet Number

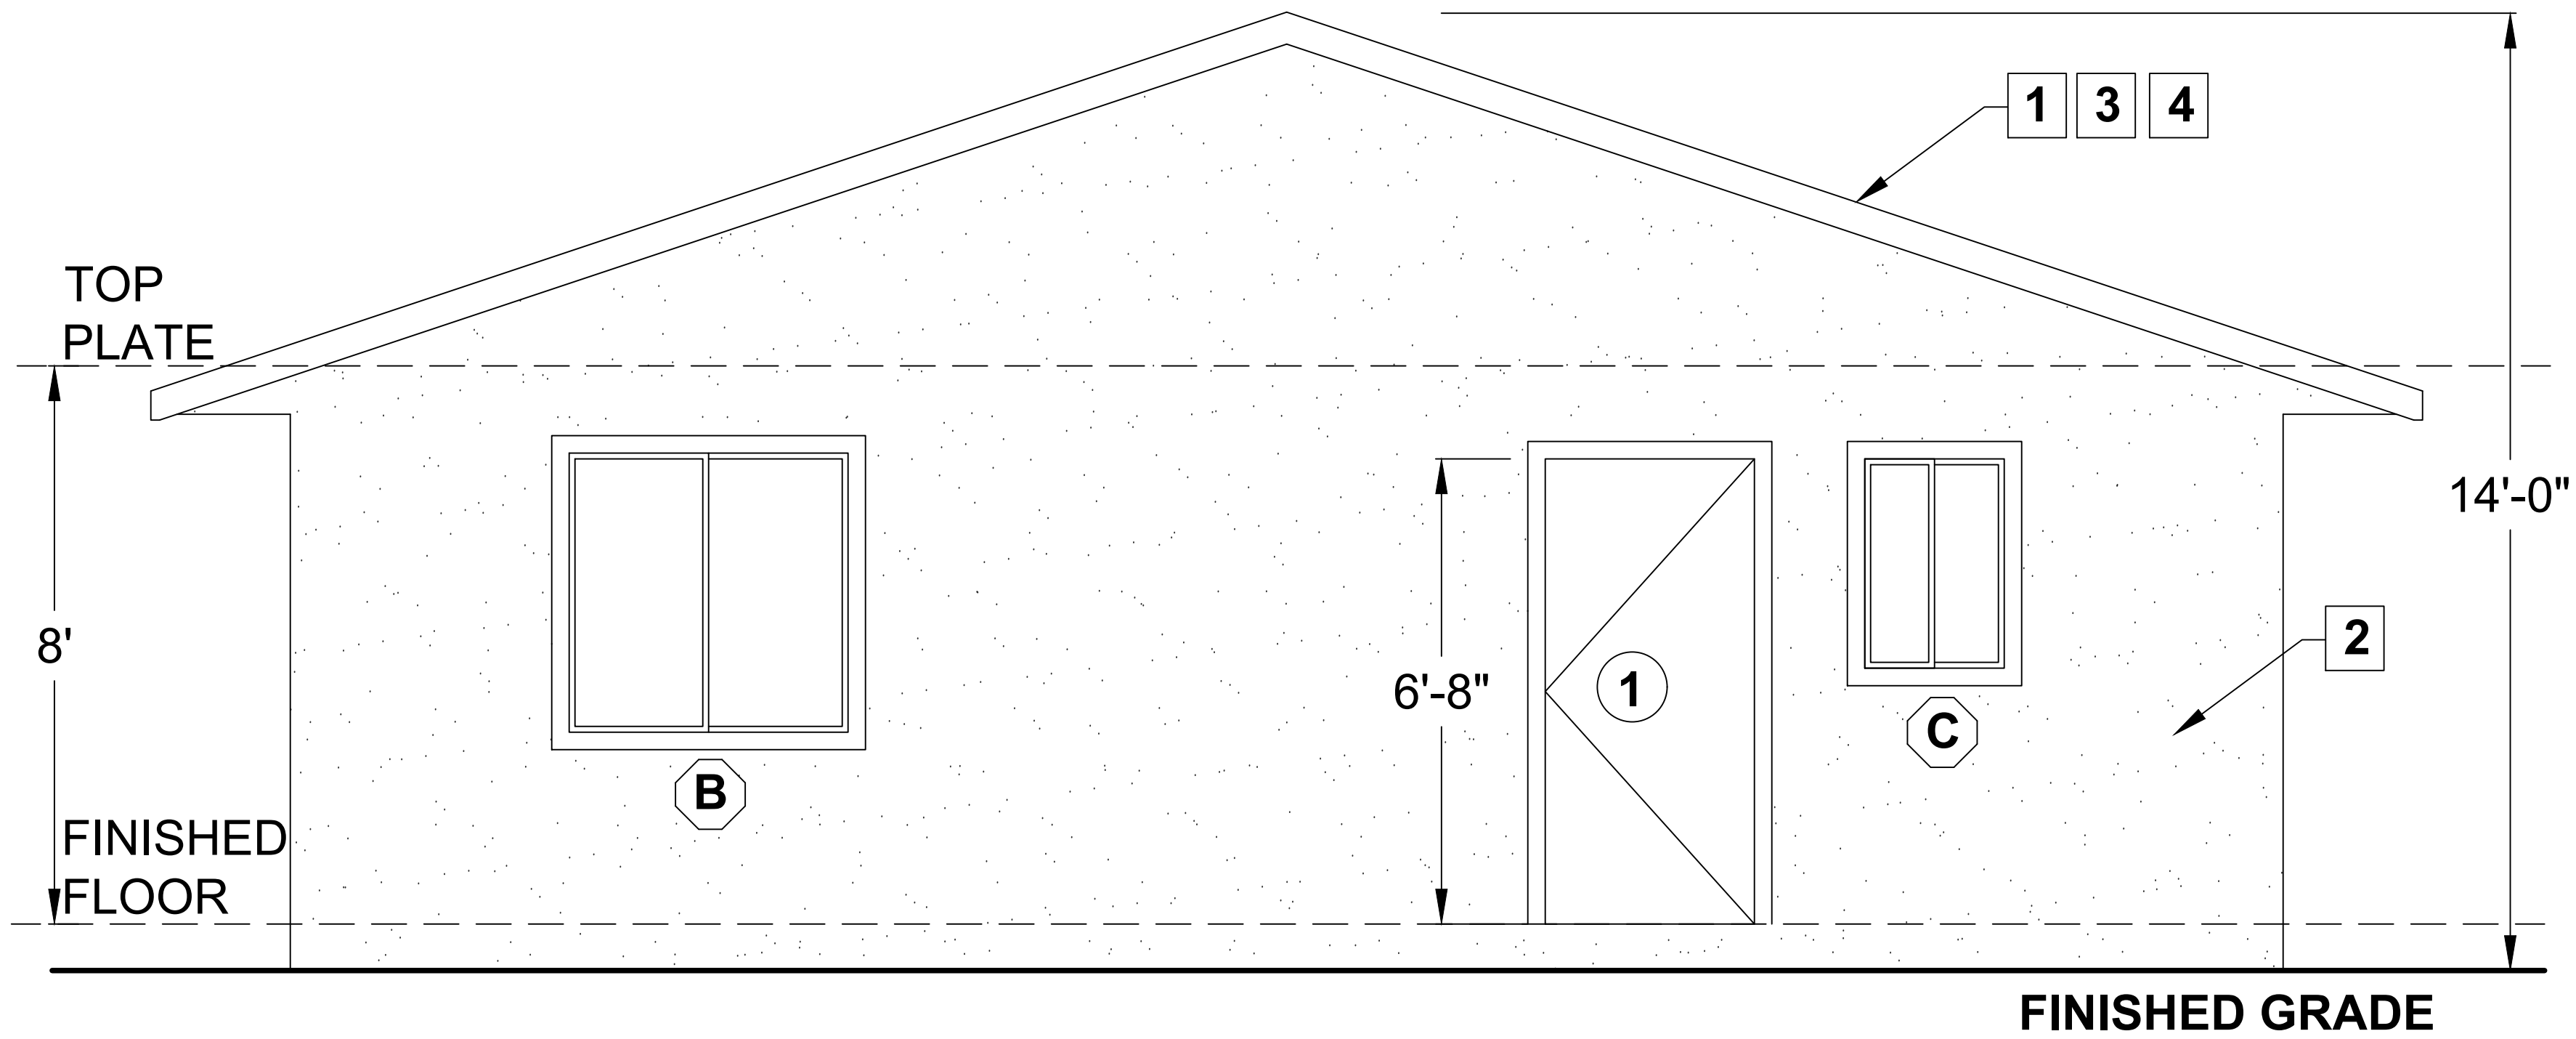

FRONT

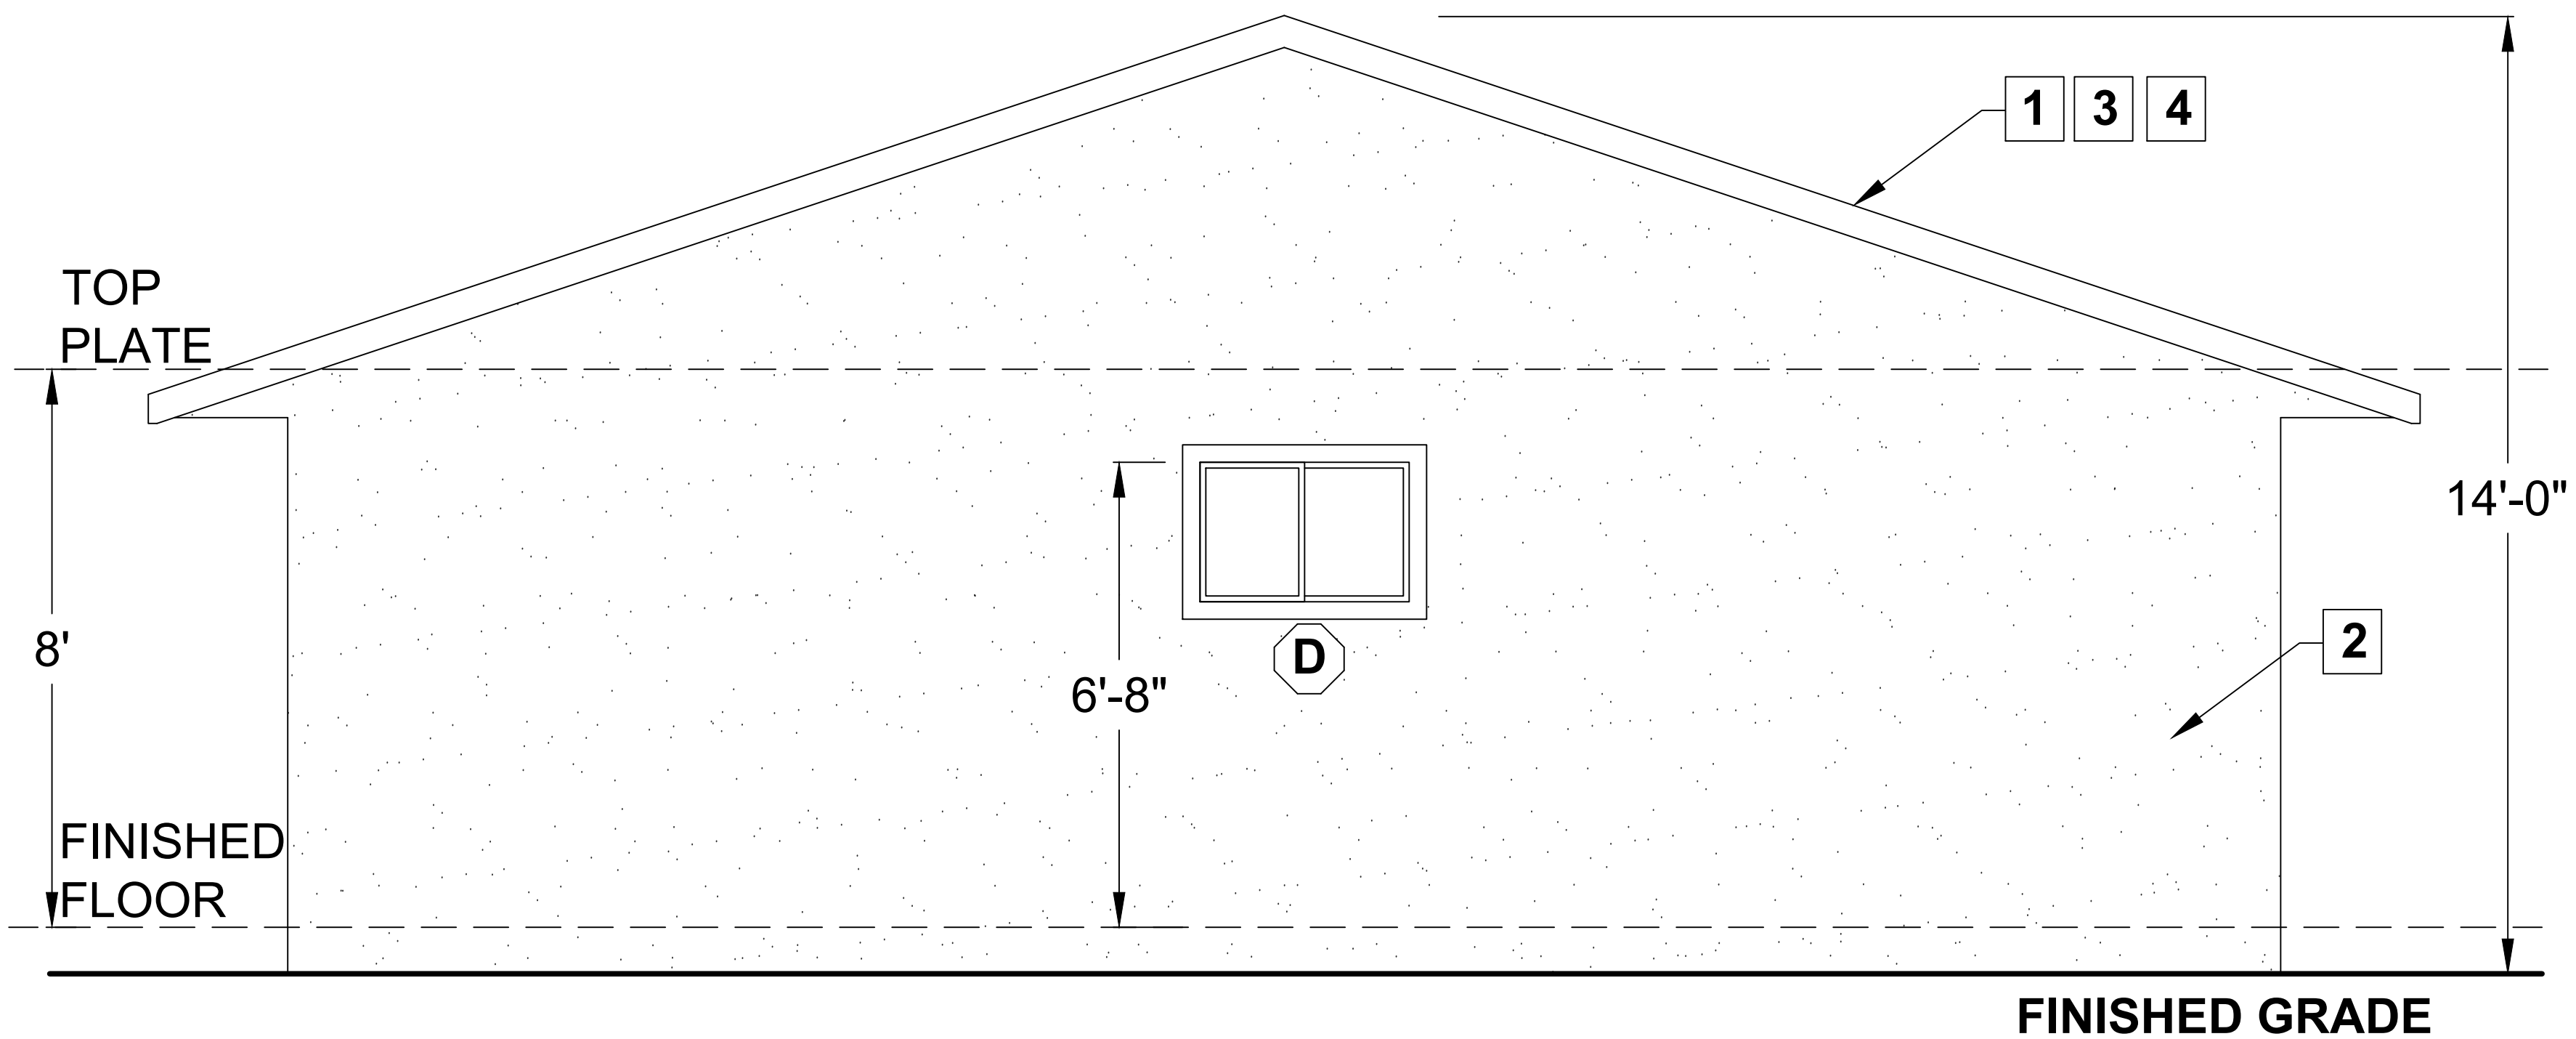

BACK

ELEVATION KEY NOTES



1. ROOF: CLASS 'C' FIRE RATING MINIMUM-
ROOF MATERIAL: _____
UNDERLAYMENT: _____
LISTING REPORT #: _____
2. EXTERIOR WALL FINISH: _____ (SEE NOTE 7 BELOW)
3. ROOF PITCH: 4:12

By using these pre-approved plans for accessory dwelling unit construction design, the user agrees to release, hold harmless, and indemnify the City of Tracy and its elected officials, employees, and agents, including the Architect who prepared these construction documents, from any and all claims, liabilities, suits, and demands on account of any injury, damage or loss to persons or property, including injury or death, or economic losses, arising out of the use of these construction documents. The use of these plans does not eliminate or reduce the user's responsibility to verify any and all information.


600 SF ACCESSORY DWELLING UNIT

Sheet Number

A3

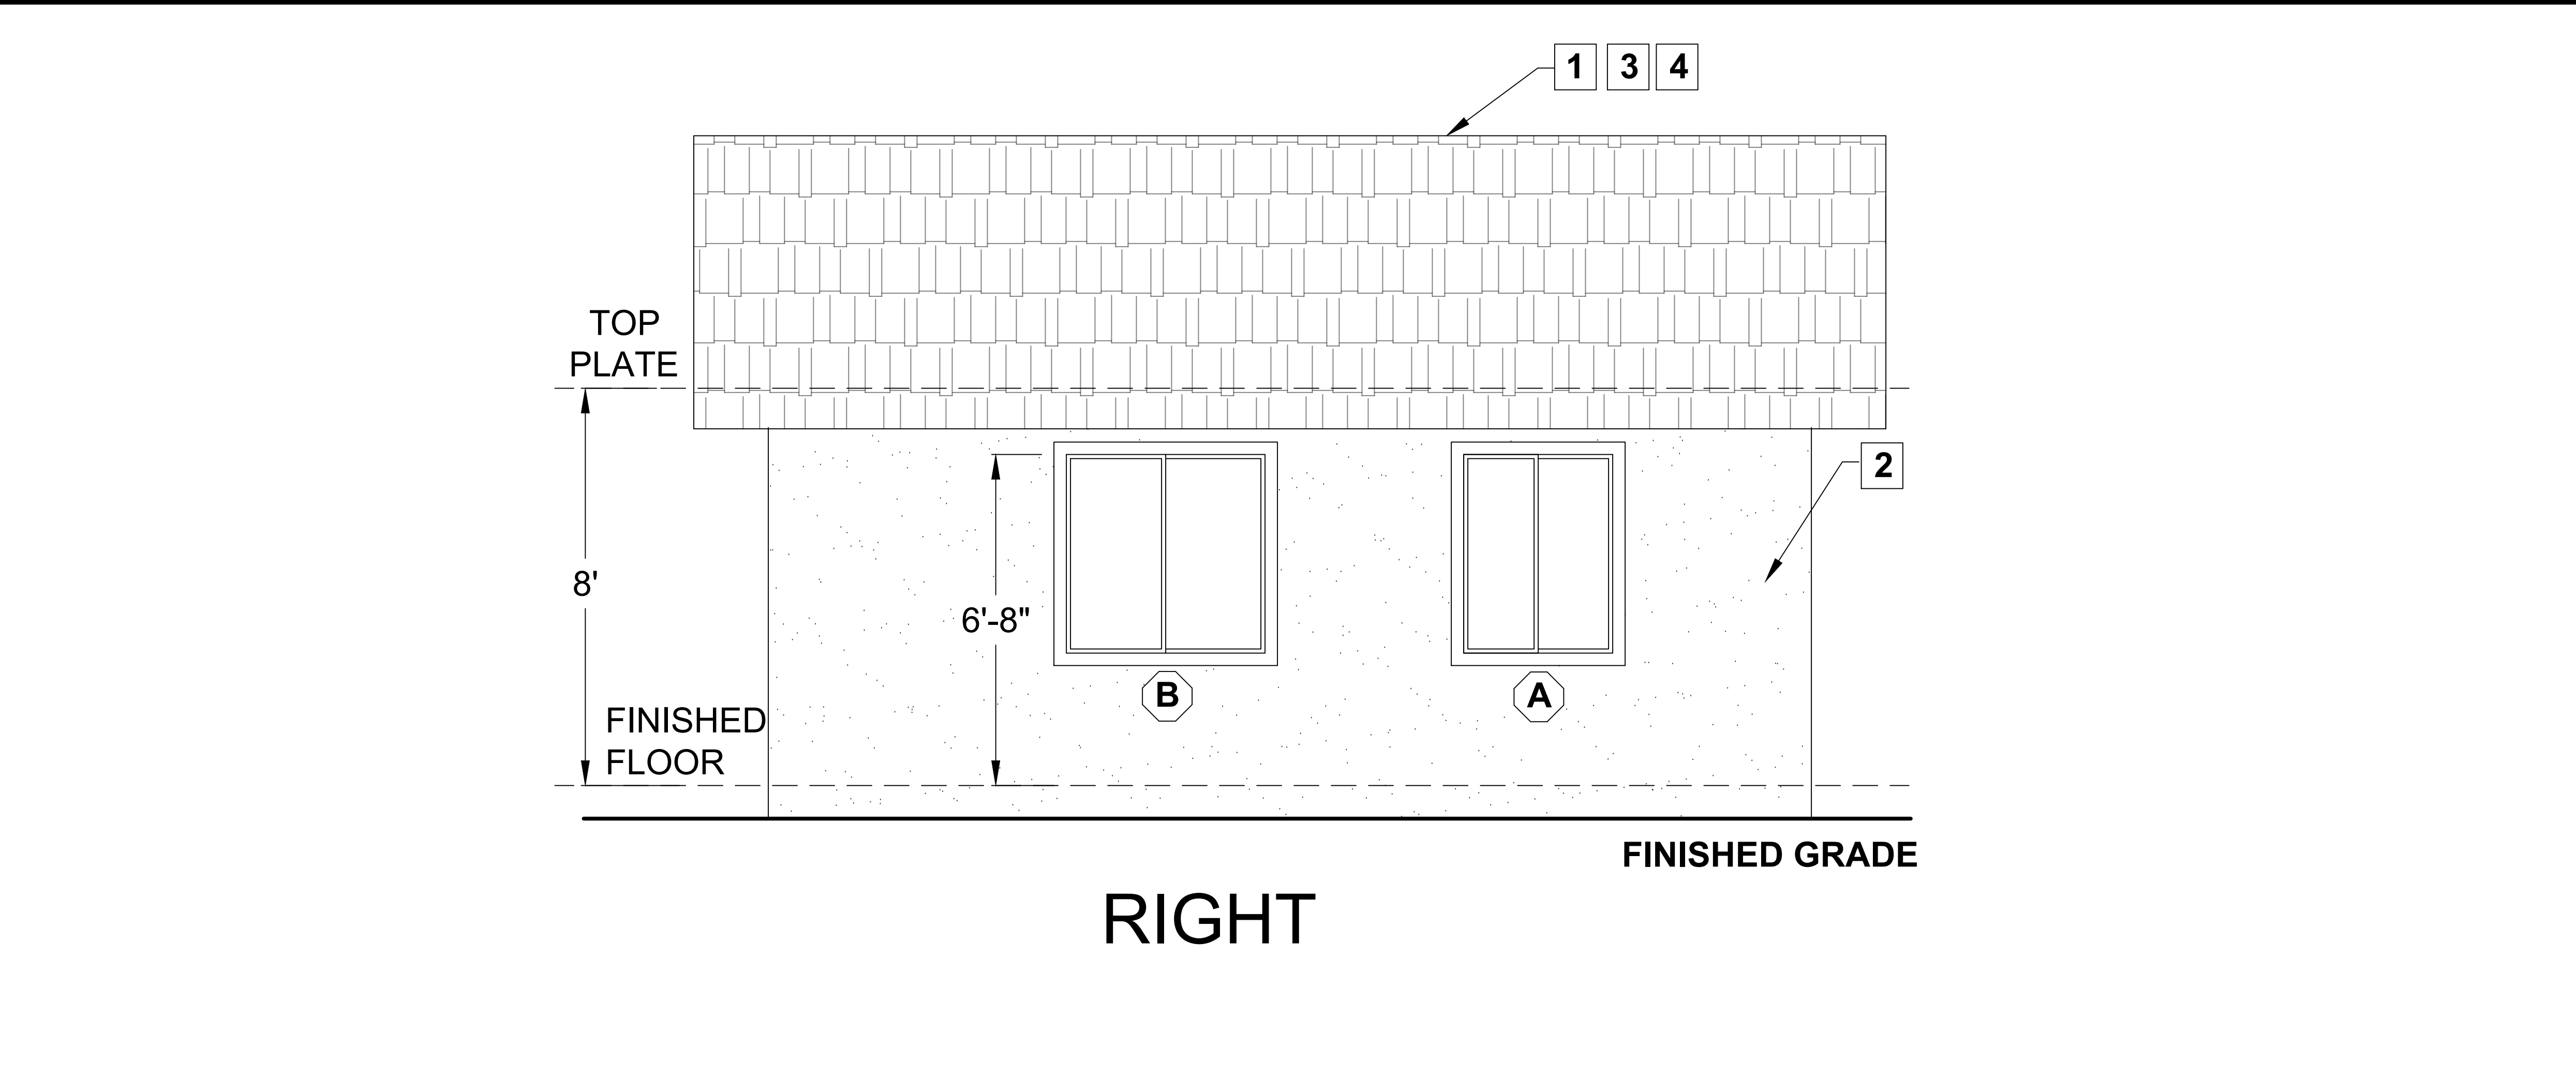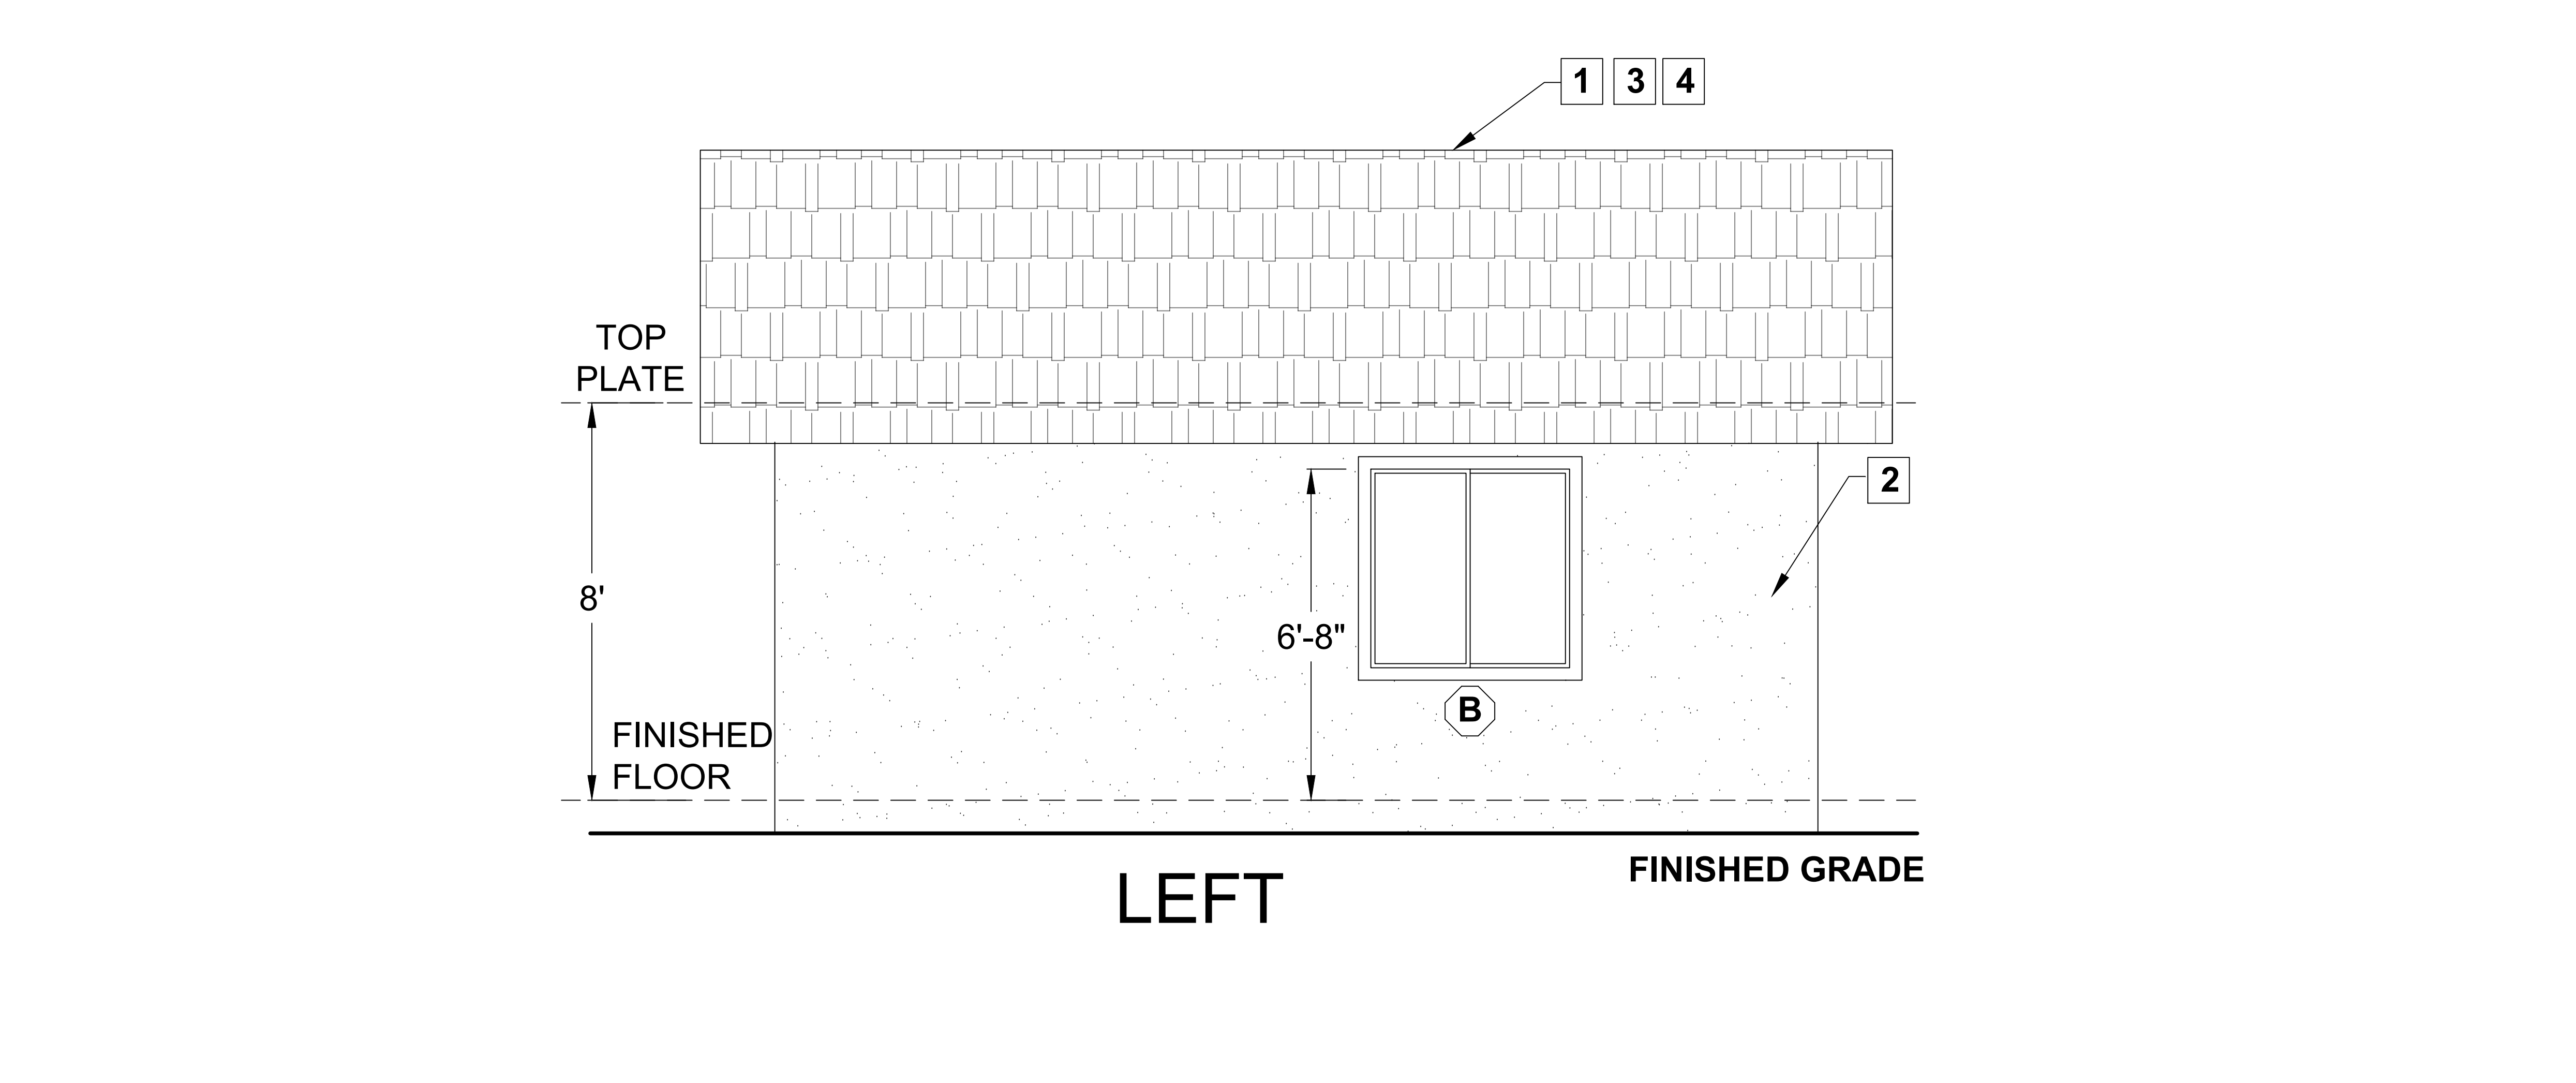

ELEVATION KEY NOTES	
SEE SHEET A3 FOR KEY NOTES	

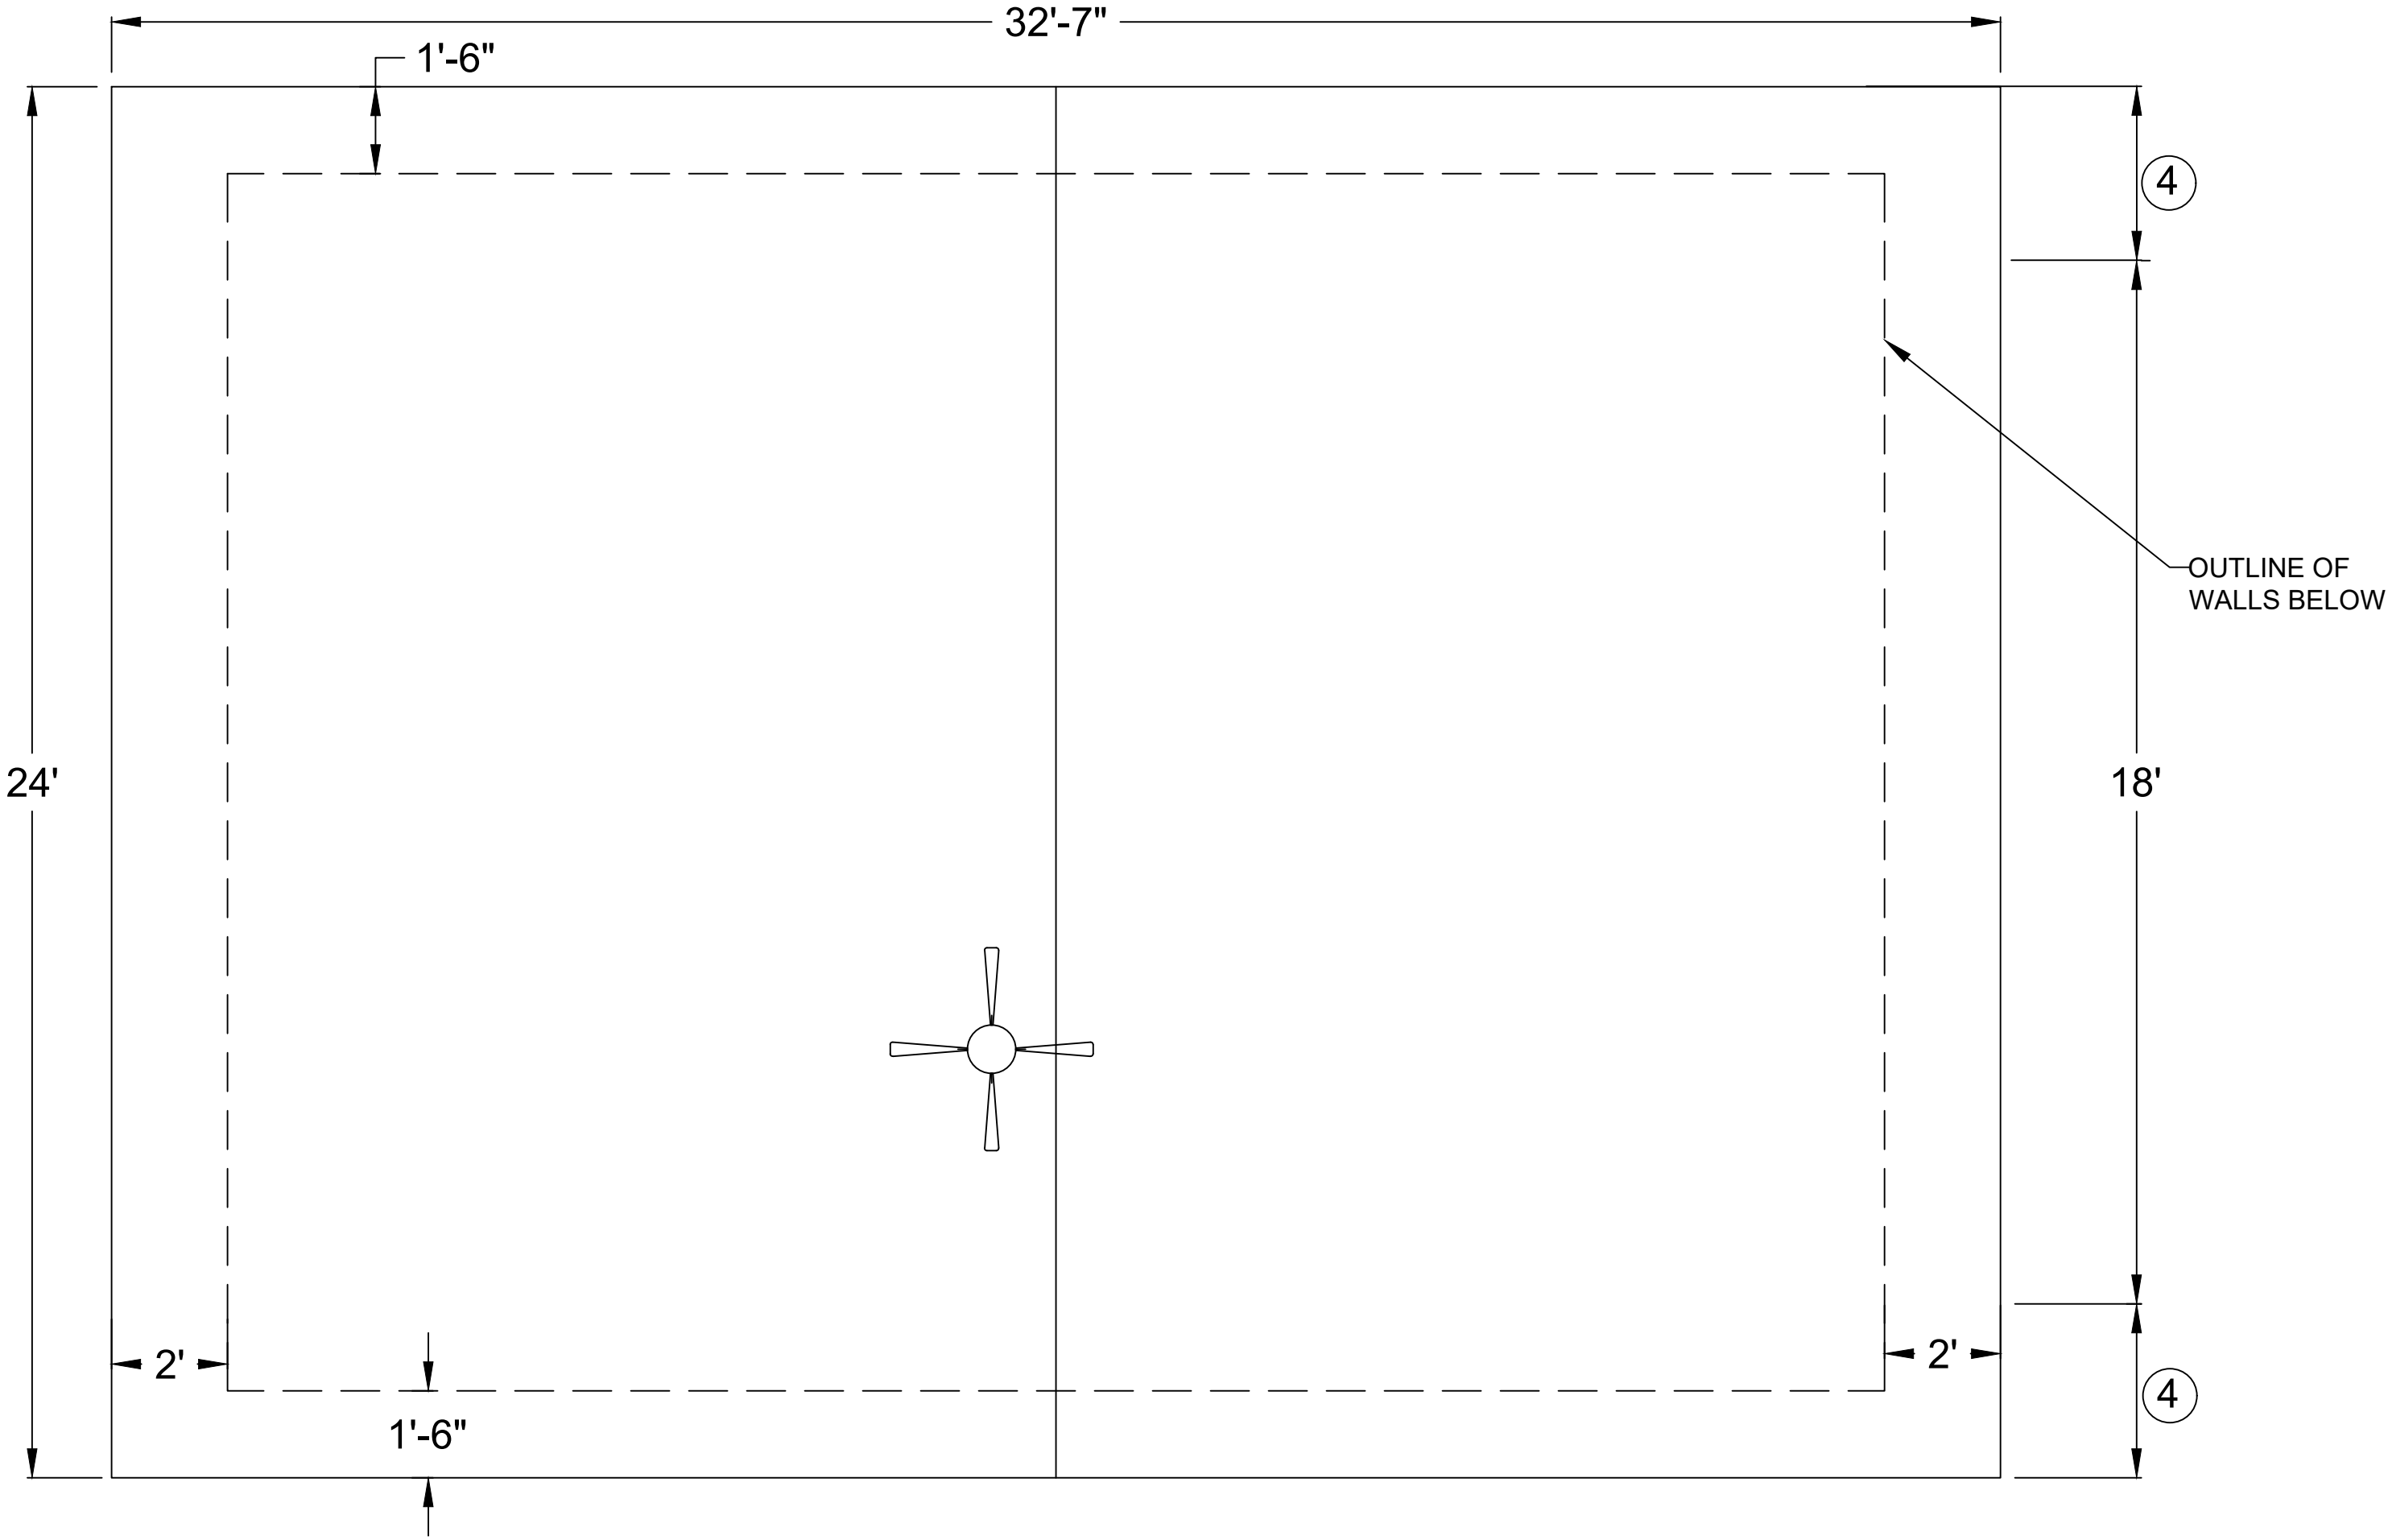


ATTIC VENTILATION REQUIRED

NET FREE CROSS VENTILATION AREA = $\frac{1}{150}$
VENT AREA REQ'D = $600 \text{ ft}^2 / 150 = 4 \text{ ft}^2 \times 144 = 576 \text{ in}^2$

ROOF VENTS
NET FREE VENTILATION AREA: 72 in^2
QTY = 8 VENTS
VENT AREA PROVIDED = $8 \times 72 \text{ in}^2 = 576 \text{ in}^2$

TOTAL VENT AREA PROVIDED
 $\frac{576 \text{ in}^2}{576 \text{ in}^2} = \frac{576 \text{ in}^2}{576 \text{ in}^2}$ OK

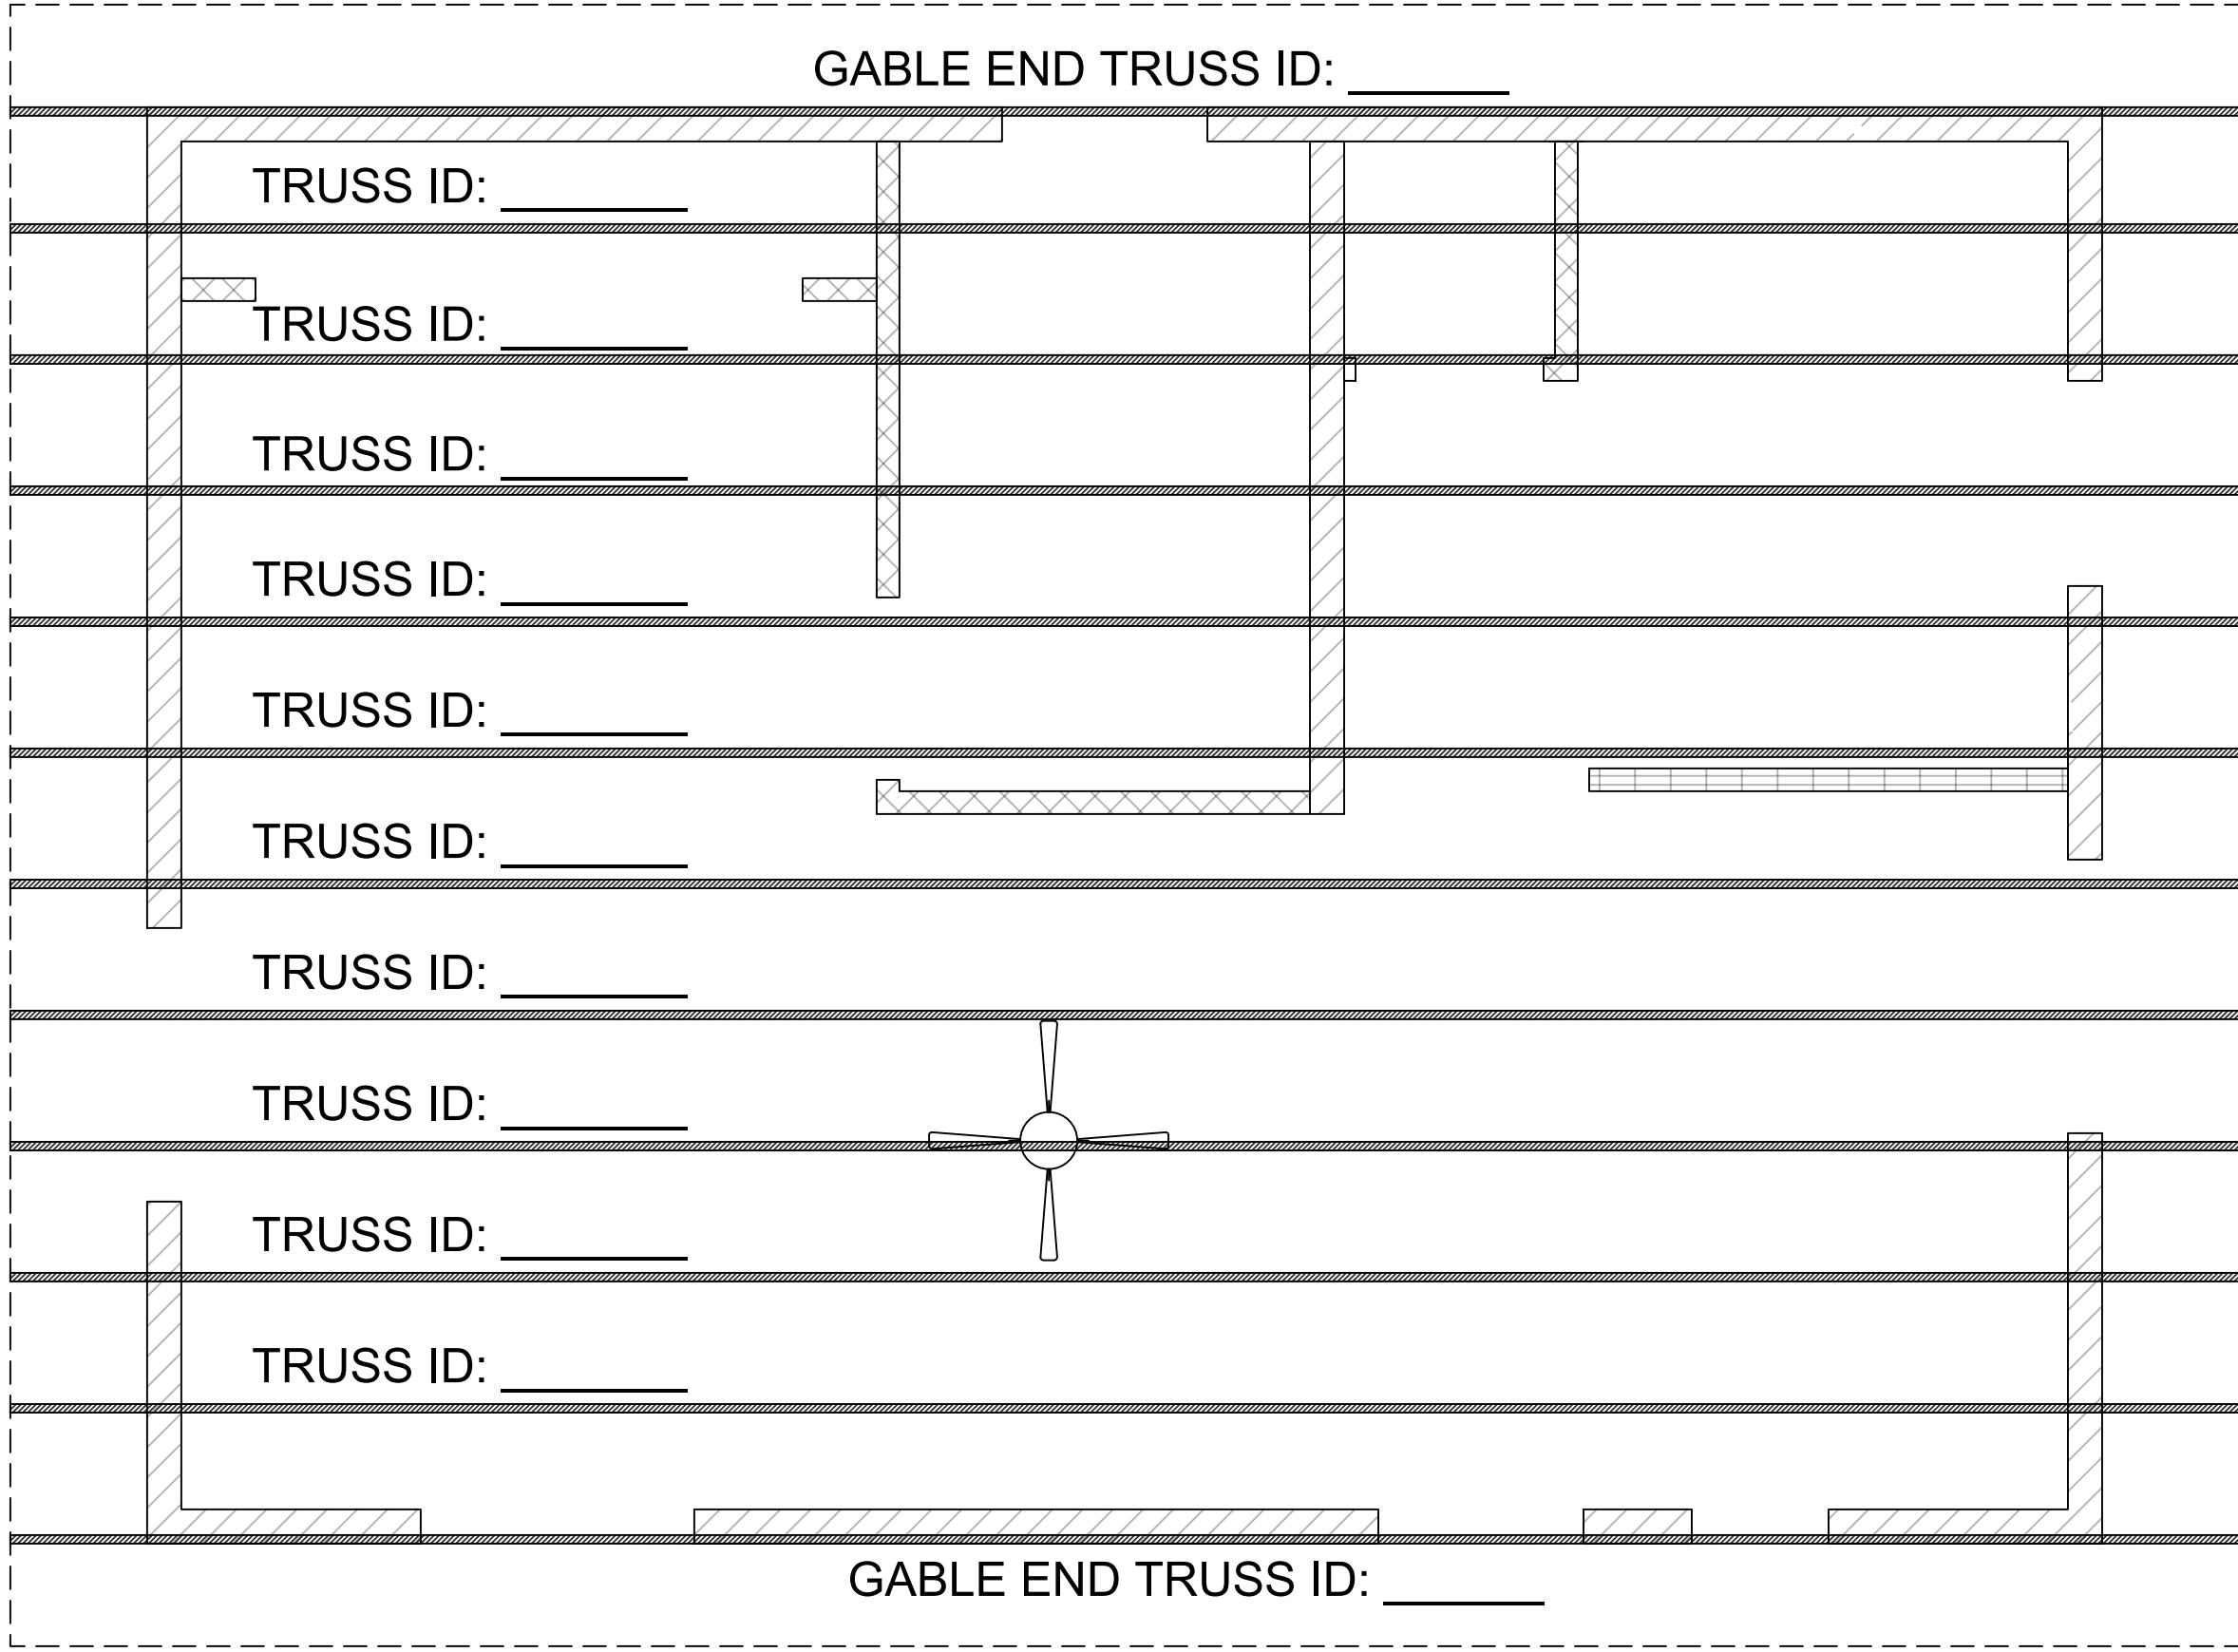

ROOF PLAN / TRUSS LAYOUT

$\frac{3}{8}'' = 1'-0''$

SOLAR NOTES


1. NO OBSTRUCTIONS - INCLUDING VENTS, CHIMNEYS, SKYLIGHTS, ARCHITECTURAL FEATURES, ROOF-MOUNTED EQUIPMENT - LOCATED WITHIN SOLAR ZONE.
2. 3' MIN FIRE FIGHTER ACCESS
3. 1'-6" SMOKE VENTILATION SETBACK AT RIDGES

By using these pre-approved plans for accessory dwelling unit construction design, the user agrees to release, hold harmless, and indemnify the City of Tracy and its elected officials, employees, and agents, including the Architect who prepared these construction documents, from any and all claims, liabilities, suits, and demands on account of any injury, damage or loss to persons or property, including injury or death, or economic losses, arising out of the use of these construction documents. The use of these plans does not eliminate or reduce the user's responsibility to verify any and all information.


600 SF ACCESSORY DWELLING UNIT

Sheet Number

A5

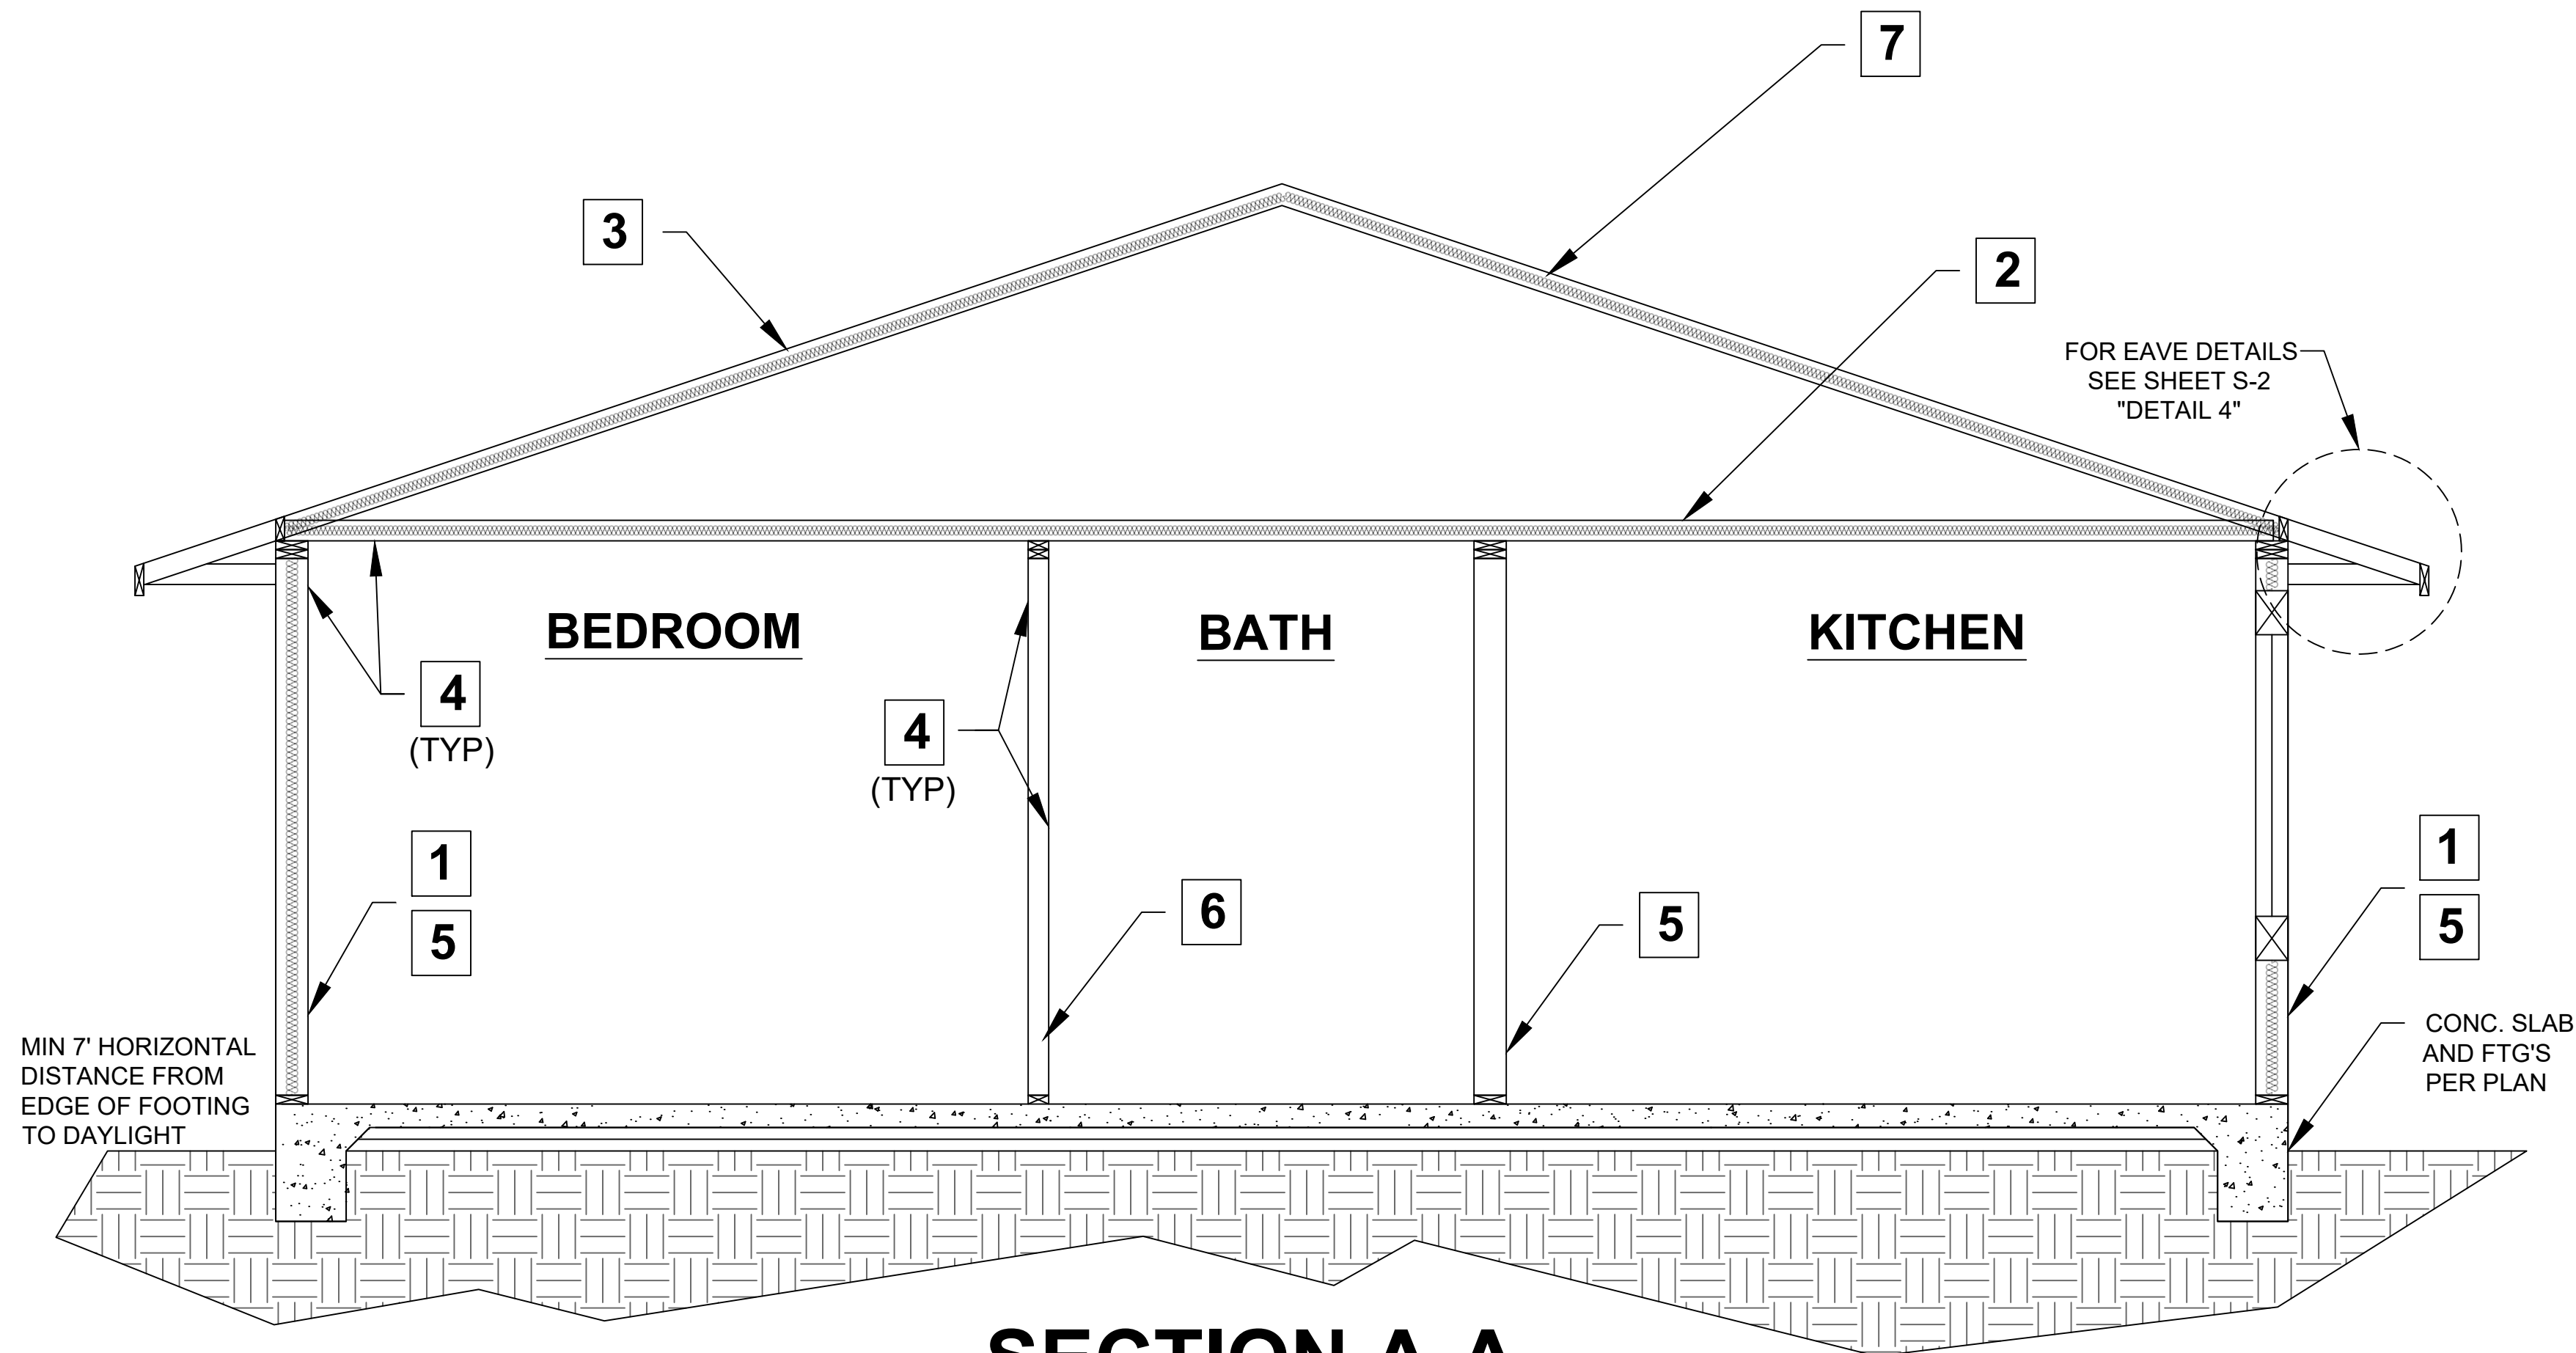

SECTION A-A

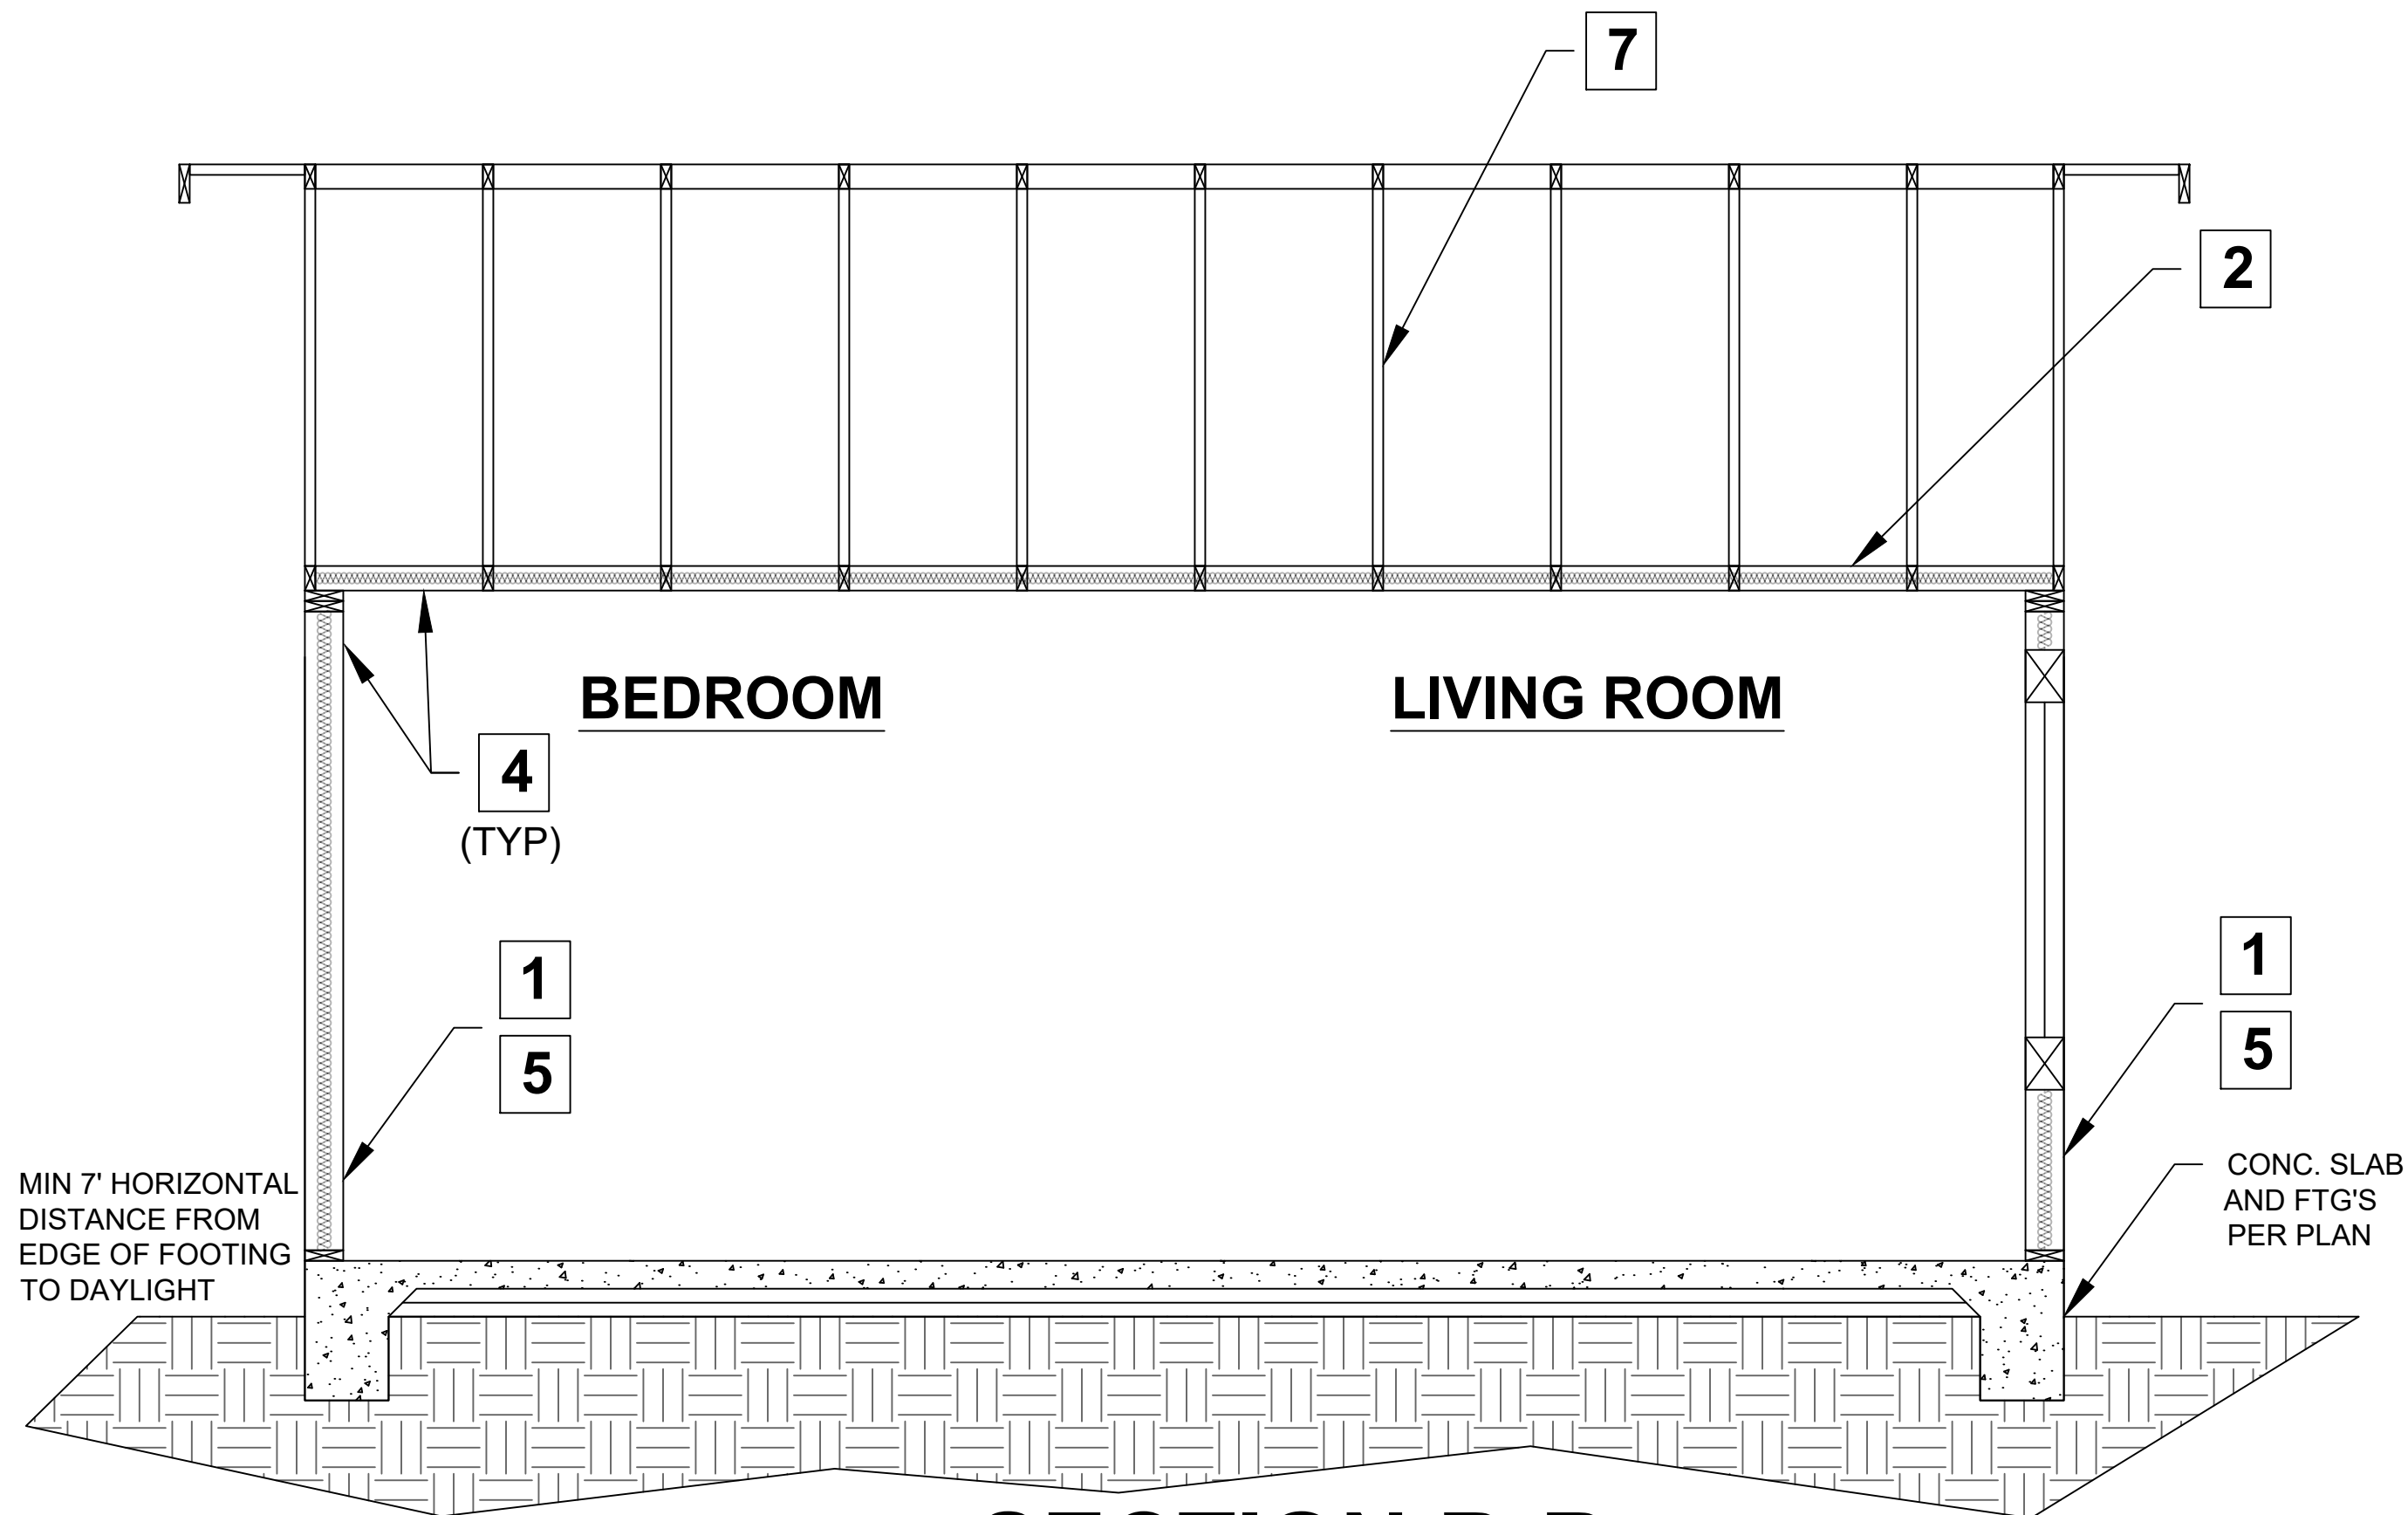

SECTION B-B

SECTION KEY NOTES



1. WALL INSULATION: _____
2. CEILING INSULATION: _____
3. ROOF (TOP CHORD) INSULATION: _____
4. INTERIOR FINISH: ½" GYPSUM BOARD
5. EXTERIOR WALL/PLUMBING WALL: 2X6 STUD WALL
6. INTERIOR WALL: 2X4 STUD WALL
7. MANUFACTURED TRUSSES

By using these pre-approved plans for accessory dwelling unit construction design, the user agrees to release, hold harmless, and indemnify the City of Tracy and its elected officials, employees, and agents, including the Architect who prepared these construction documents, from any and all claims, liabilities, suits, and demands on account of any injury, damage or loss to persons or property, including injury or death, or economic losses, arising out of the use of these construction documents. The use of these plans does not eliminate or reduce the user's responsibility to verify any and all information.

600 SF ACCESSORY DWELLING UNIT

Sheet Number

A6

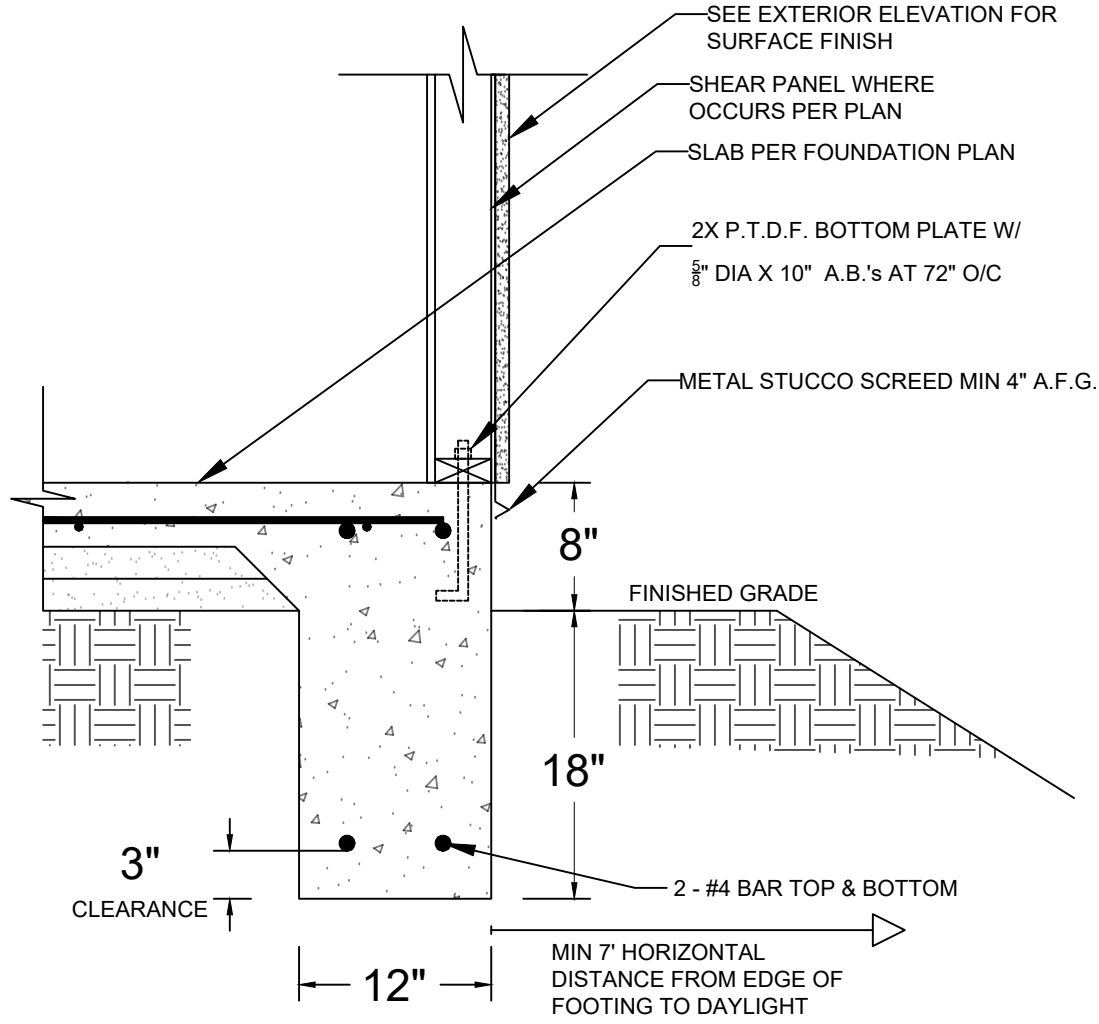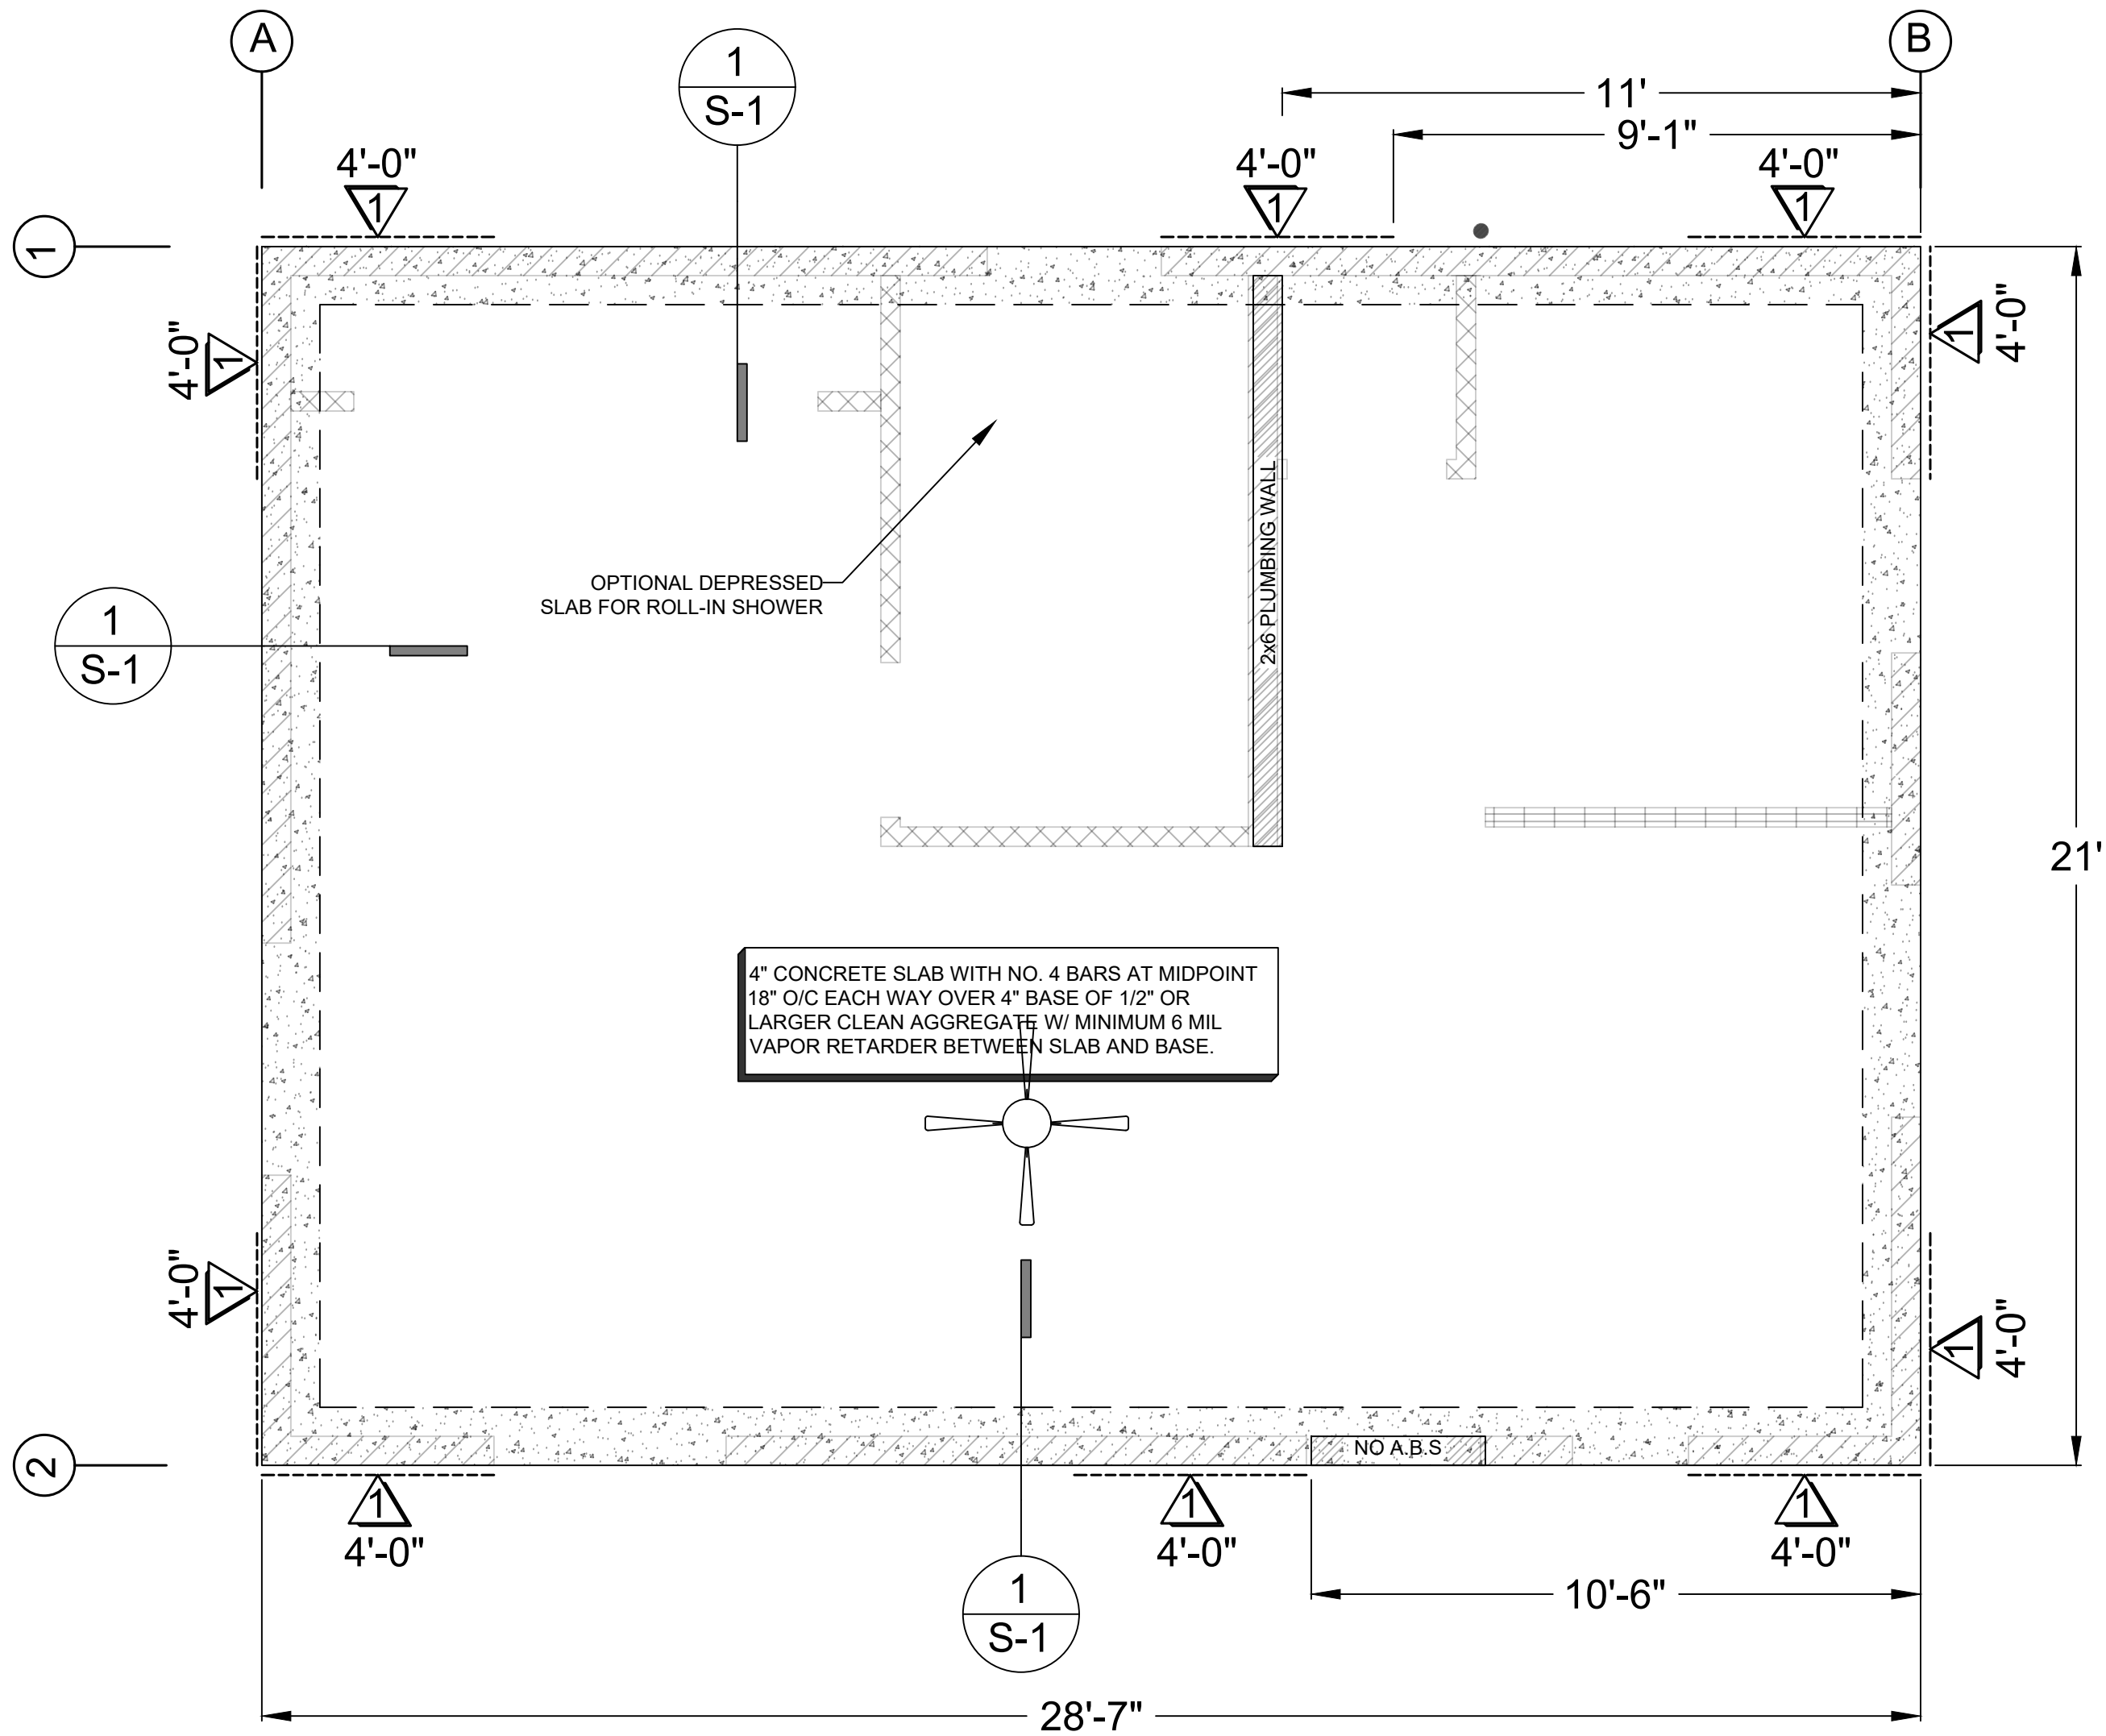


DETAIL 1
(NTS)

FOUNDATION PLAN NOTES

- ALL ANCHORS BOLTS SHALL BE $\frac{3}{8}$ " DIAMETER AND HAVE A MINIMUM EMBEDMENT OF 7 INCHES INTO CONCRETE (UNO) AND NOT SPACED MORE THAN 6 FEET APART
- 3"X3"X0.229" PLATE WASHERS SHALL BE USED ON EACH SILL PLATE ANCHOR BOLT
- FOR STANDARD CUT WASHERS PLACED BETWEEN PLATE WASHER AND NUT, HOLE IN PLATE WASHER MAY BE DIAGONALLY SLOTTED WITH MAXIMUM $\frac{3}{4}$ " LARGER WIDTH THAN BOLT DIAMETER AND MAXIMUM 1-3/4" SLOT LENGTH
- PROVIDE A MINIMUM OF TWO ANCHOR BOLTS PER SILL PLATE WITH ONE BOLT LOCATED MAXIMUM 12" AND MINIMUM 7 BOLT DIAMETERS FROM EACH END OF EACH SECTION.
- BOLTS LOCATED IN THE MIDDLE THIRD OF THE SILL PLATE WIDTH
- FASTENERS FOR PRESSURE-PRESERVATIVE TREATED AND FIRE RETARDANT TREATED WOOD SHALL BE HOT-DIPPED ZINC COATED GALVANIZED, STAINLESS STEEL OR COPPER
- NO LPG PIPING ASSEMBLIES ALLOWED IN OR BENEATH SLABS WITHIN THE STRUCTURE

LEGEND

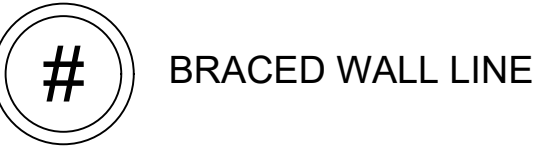

WOOD STRUCTURAL PANEL SHEATHING							
MARK	MINIMUM NAIL		MINIMUM WOOD STRUCTURAL PANEL SPAN RATING	MINIMUM NOMUNAL PANEL THICKNESS (in)	MAXIMUM WALL STUD SPACING (in)	PANEL NAIL SPACING	
	SIZE	PENETRATION (in)				EDGES (inches o/c)	FIELD (inches o/c)
1	6D COMMON	1.5	24:0	$\frac{3}{8}$ "	16	6	12
	8D COMMON	1.75	24:16	$\frac{7}{16}$ "	16	6	12

WOOD STRUCTURAL PANELS SHALL CONFORM TO DOC PS 1, DOC PS 2 OR ANSI/APA PRP 210, CSA O437 OR CSA O325. PANELS SHALL BE IDENTIFIED BY A GRADE MARK OR CERTIFICATE OF INSPECTION ISSUED BY AN APPROVED AGENCY

VERTICAL JOINTS OF PANEL SHEATHING SHALL OCCUR OVER AND BE FASTENED TO COMMON STUDS. HORIZONTAL JOINTS IN BRACED WALL PANELS SHALL OCCUR OVER AND BE FASTENED TO COMMON BLOCKING OF A MINIMUM $1\frac{1}{2}$ INCH THICKNESS.

By using these pre-approved plans for accessory dwelling unit construction design, the user agrees to release, hold harmless, and indemnify the City of Tracy and its elected officials, employees, and agents, including the Architect who prepared these construction documents, from any and all claims, liabilities, suits, and demands on account of any injury, damage or loss to persons or property, including injury or death, or economic losses, arising out of the use of these construction documents. The use of these plans does not eliminate or reduce the user's responsibility to verify any and all information.


600 SF ACCESSORY DWELLING UNIT

Sheet Number


S1

FOUNDATION PLAN


3/8" = 1'-0"

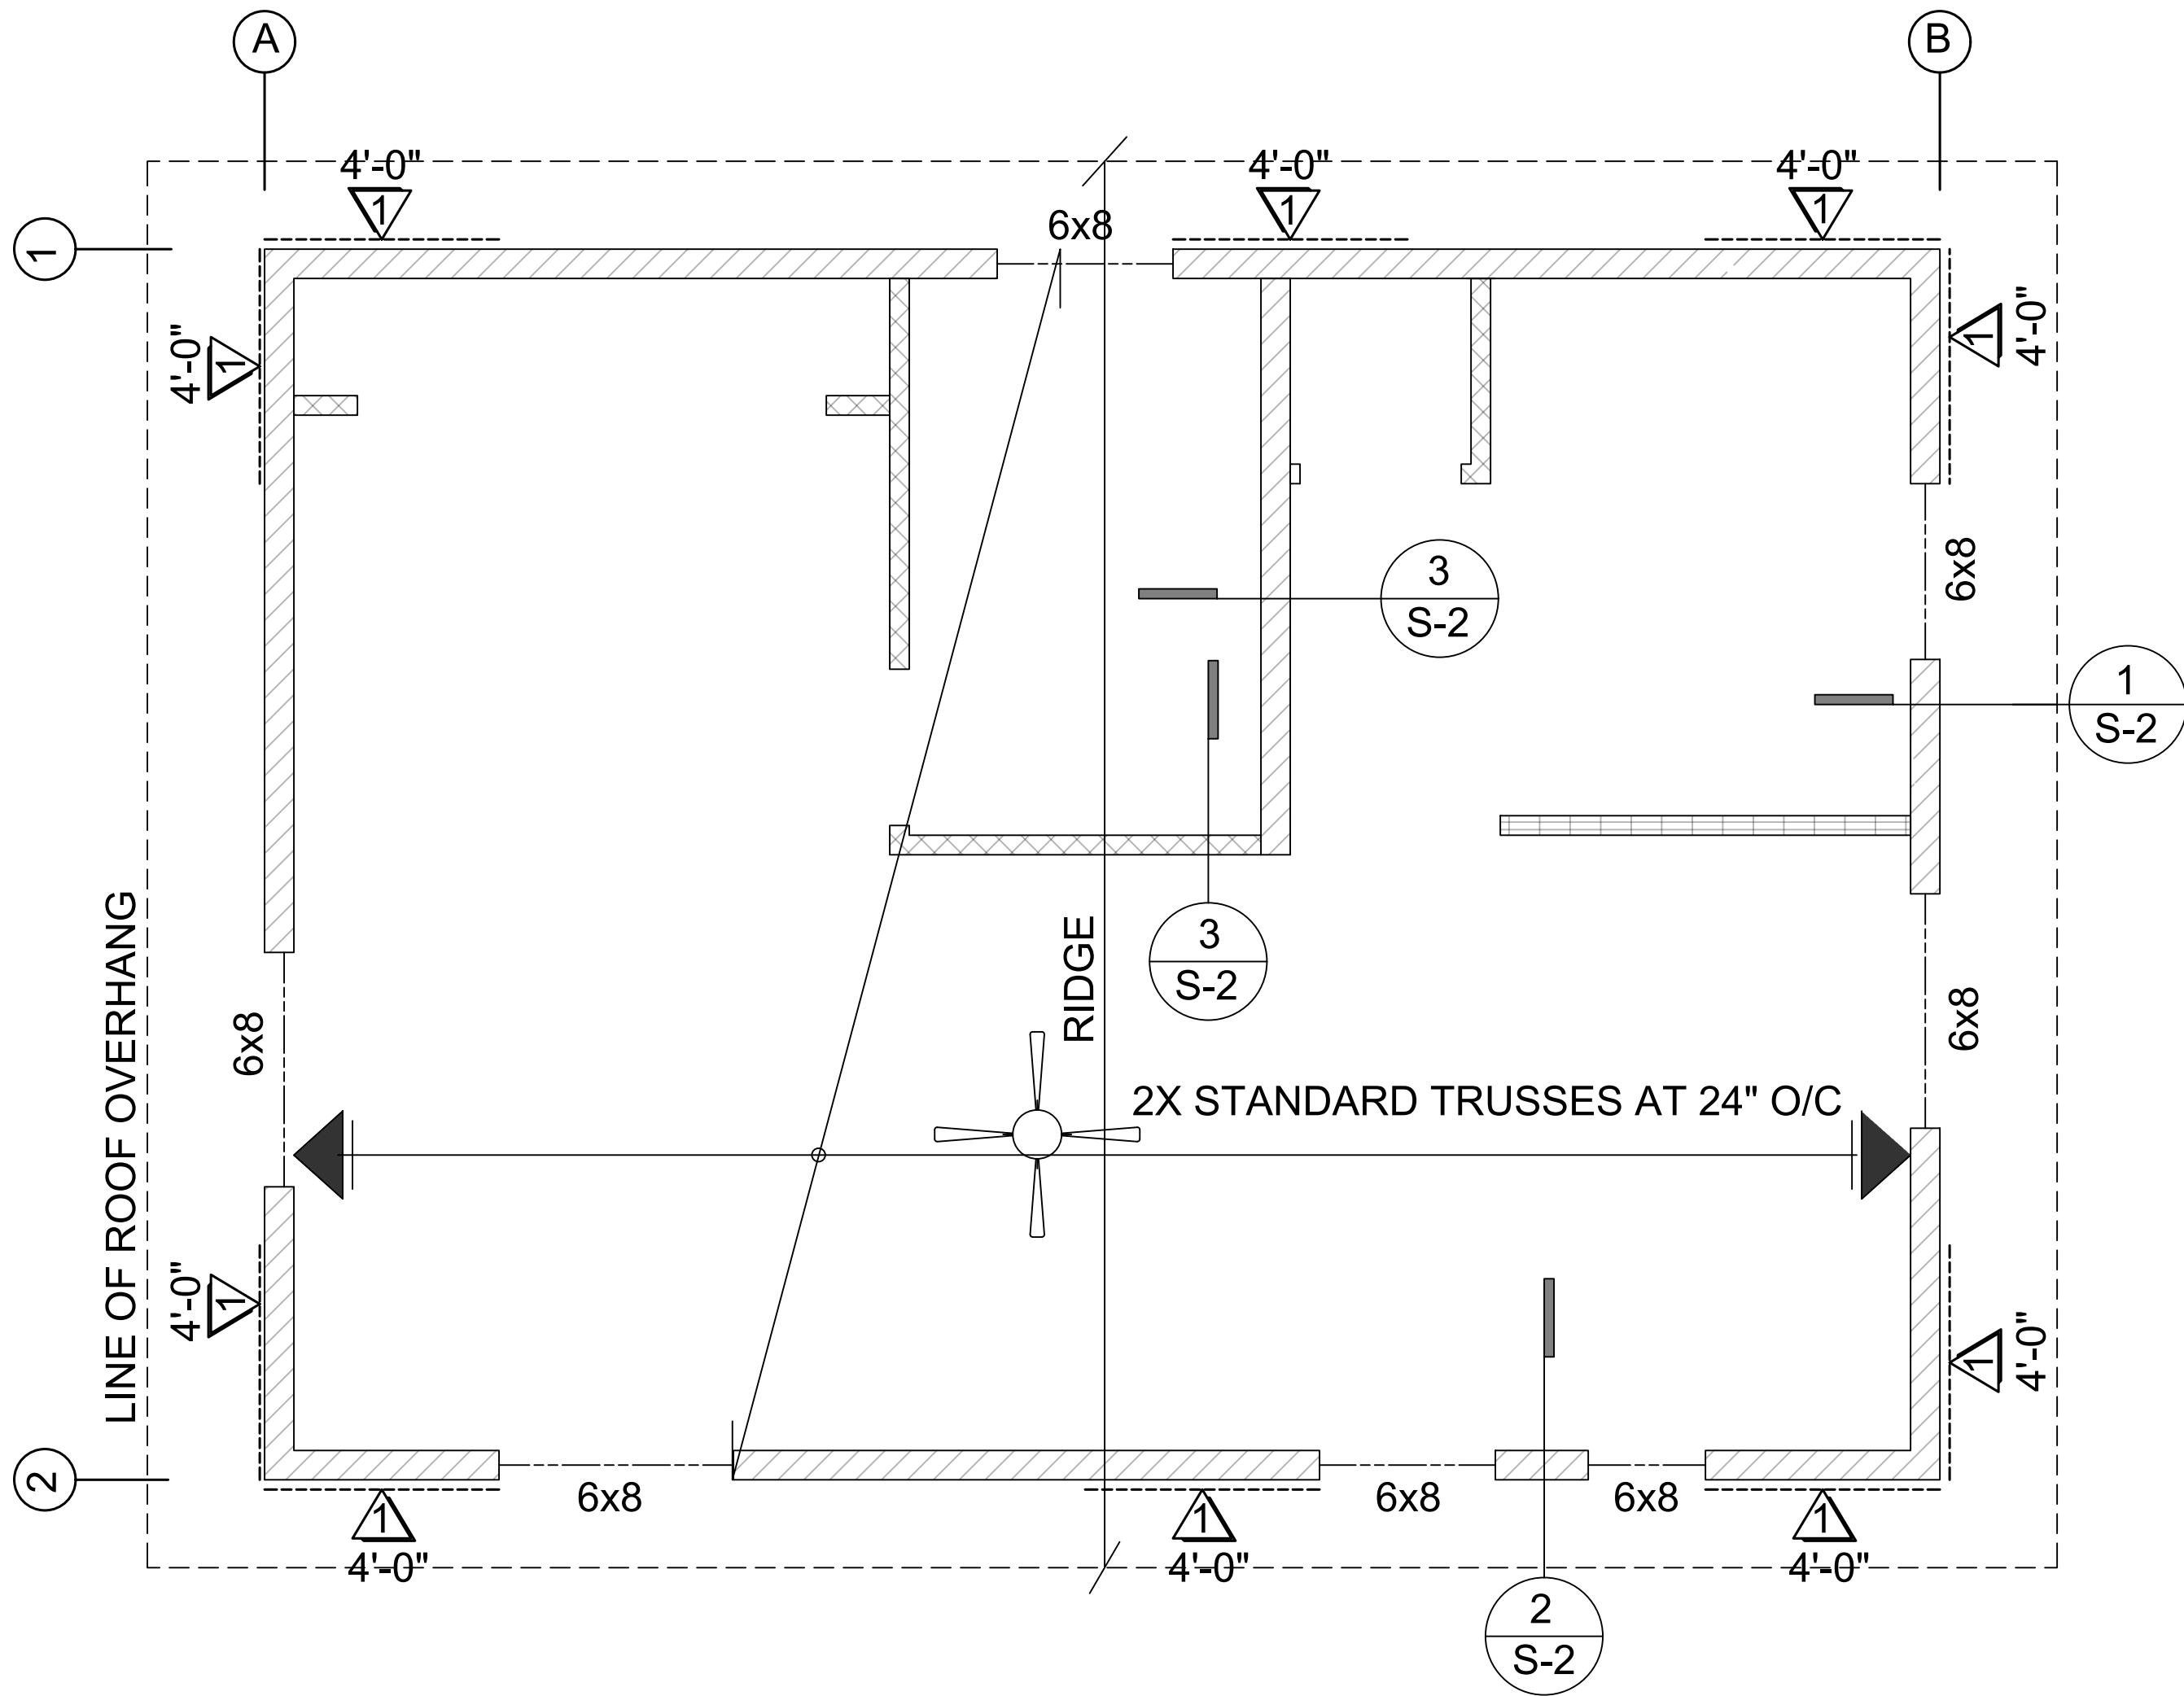


NOTE: ROOF SHEATHING TO BE 1/2" APA RATED SHEATHING 24:0 AT 6" O/C EDGE NAILING AND 6" O/C FIELD NAILING

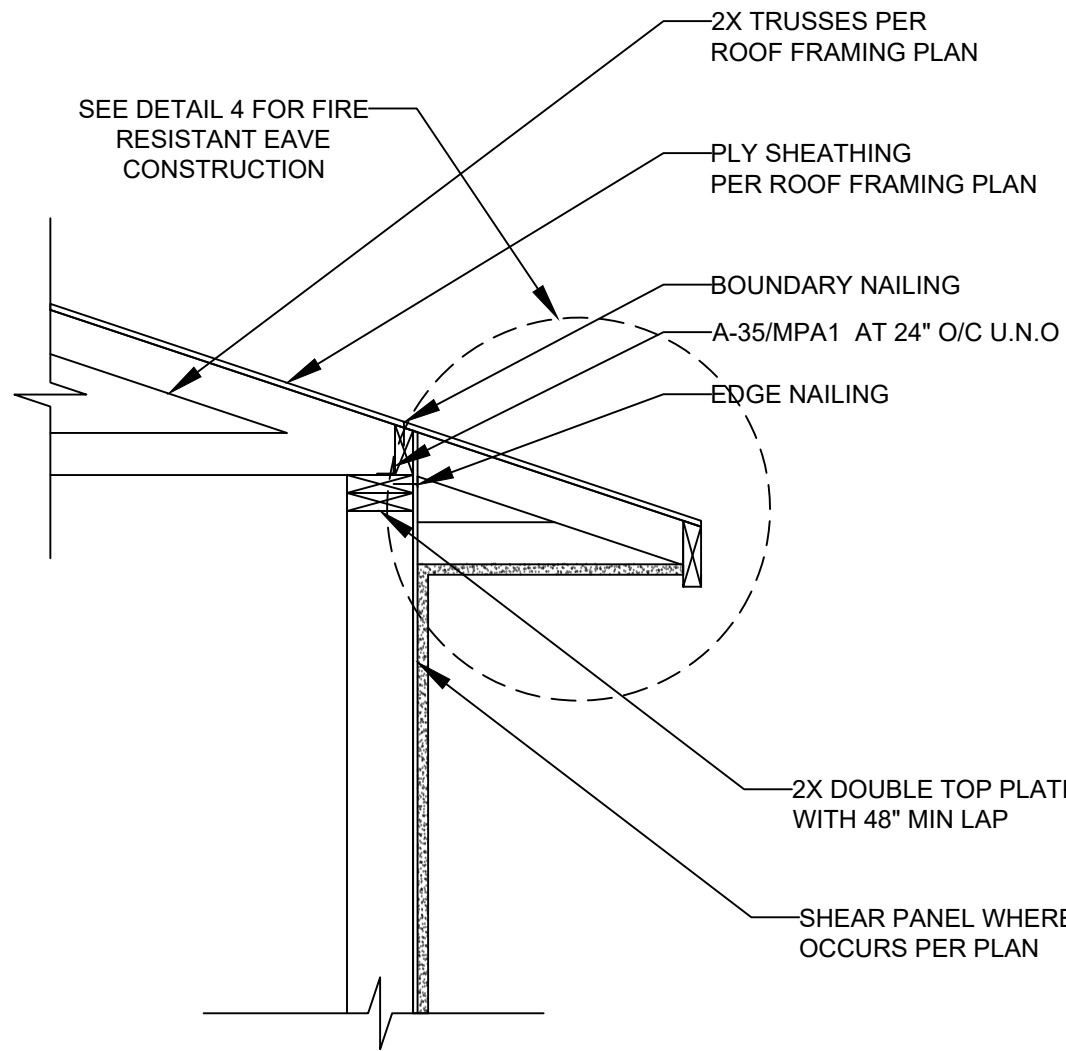


DETAIL 1
(NTS)

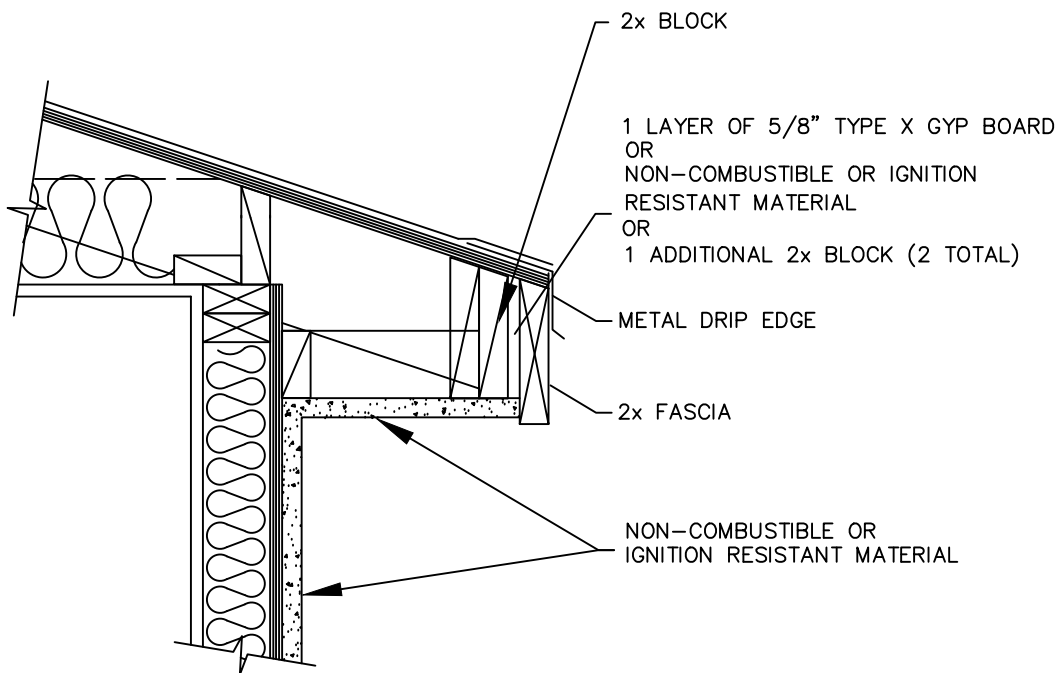


DETAIL 4
(NTS)

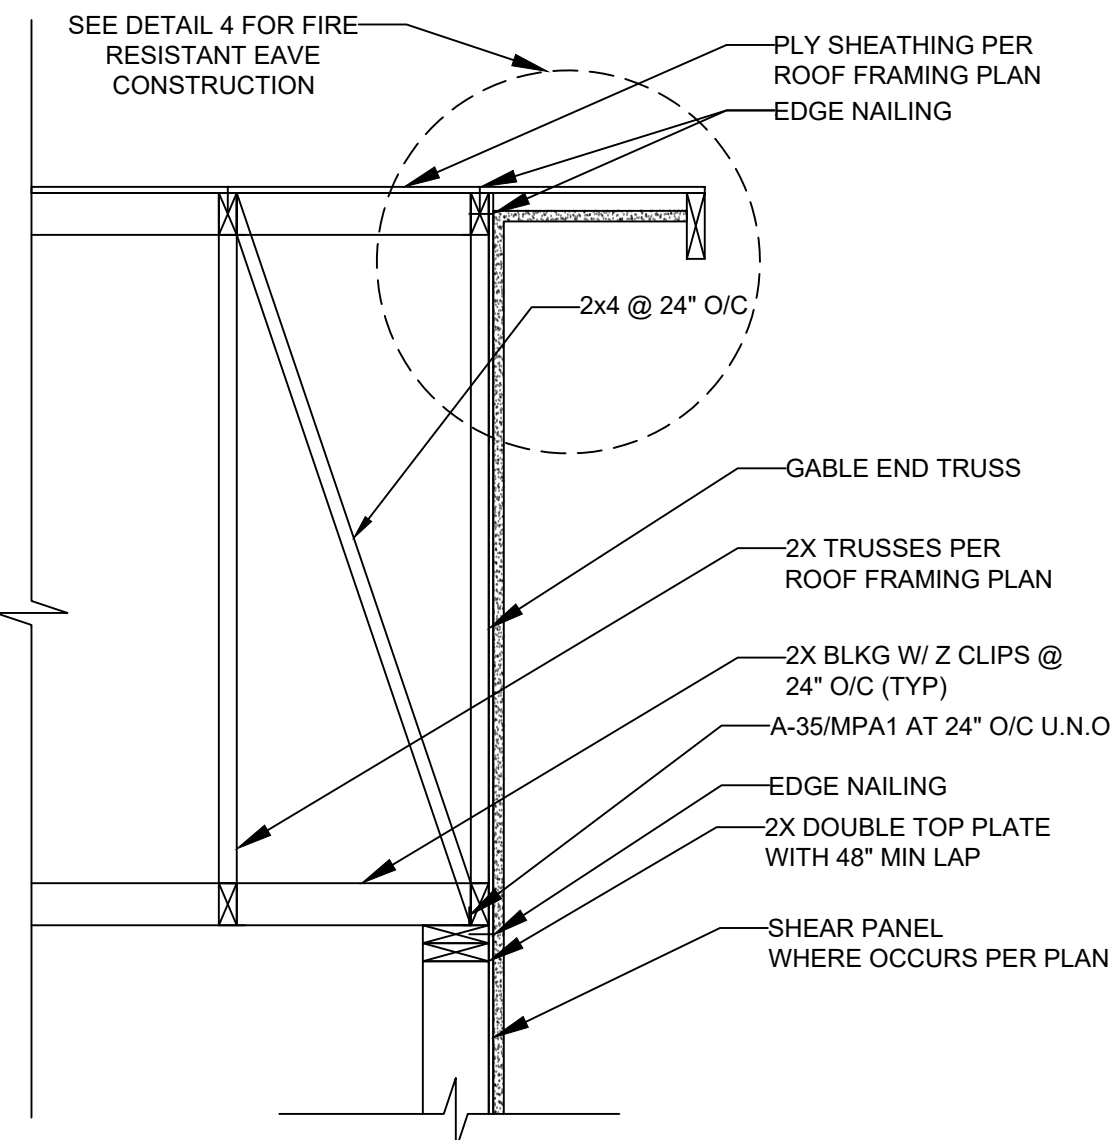

DETAIL 2
(NTS)

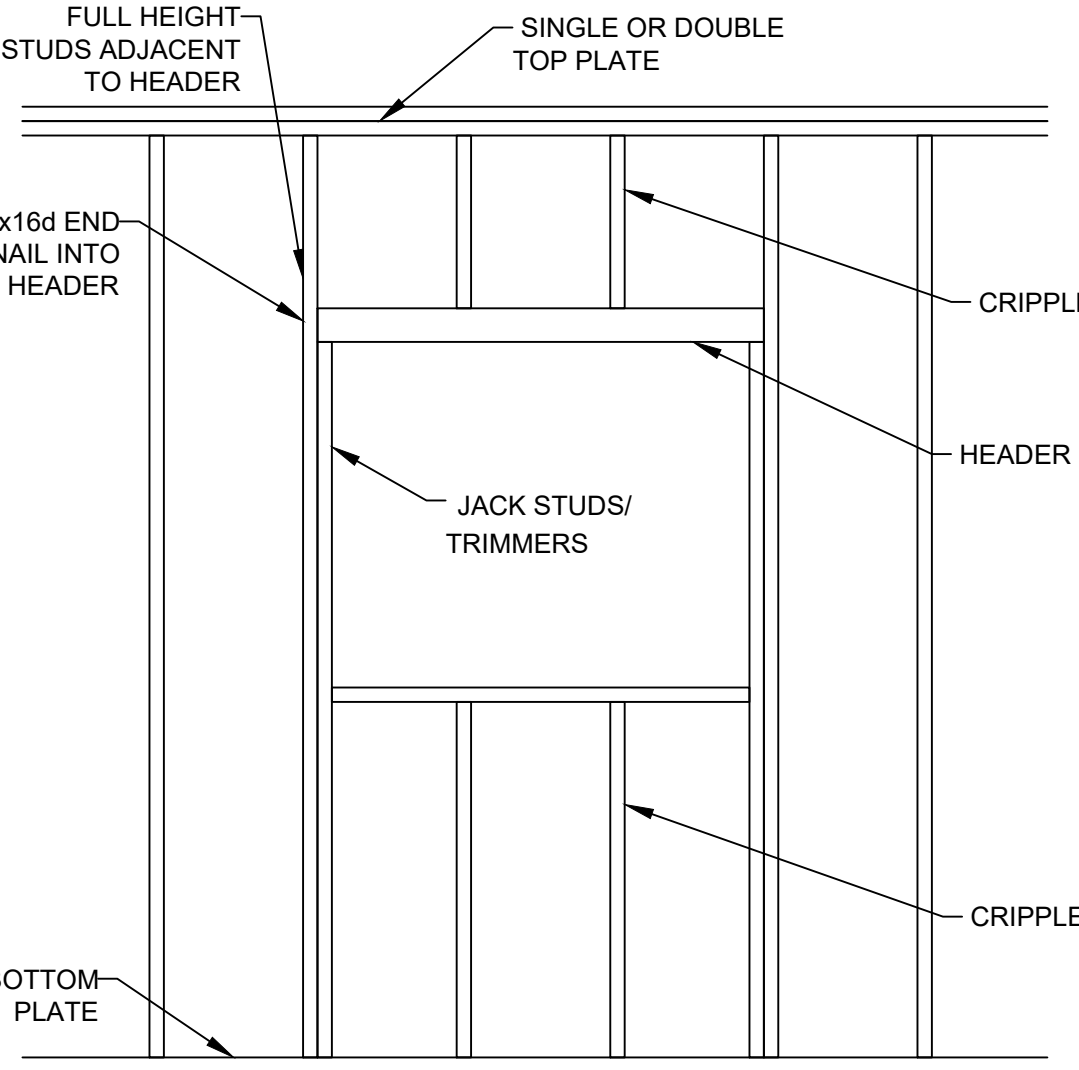

DETAIL 5
(NTS)

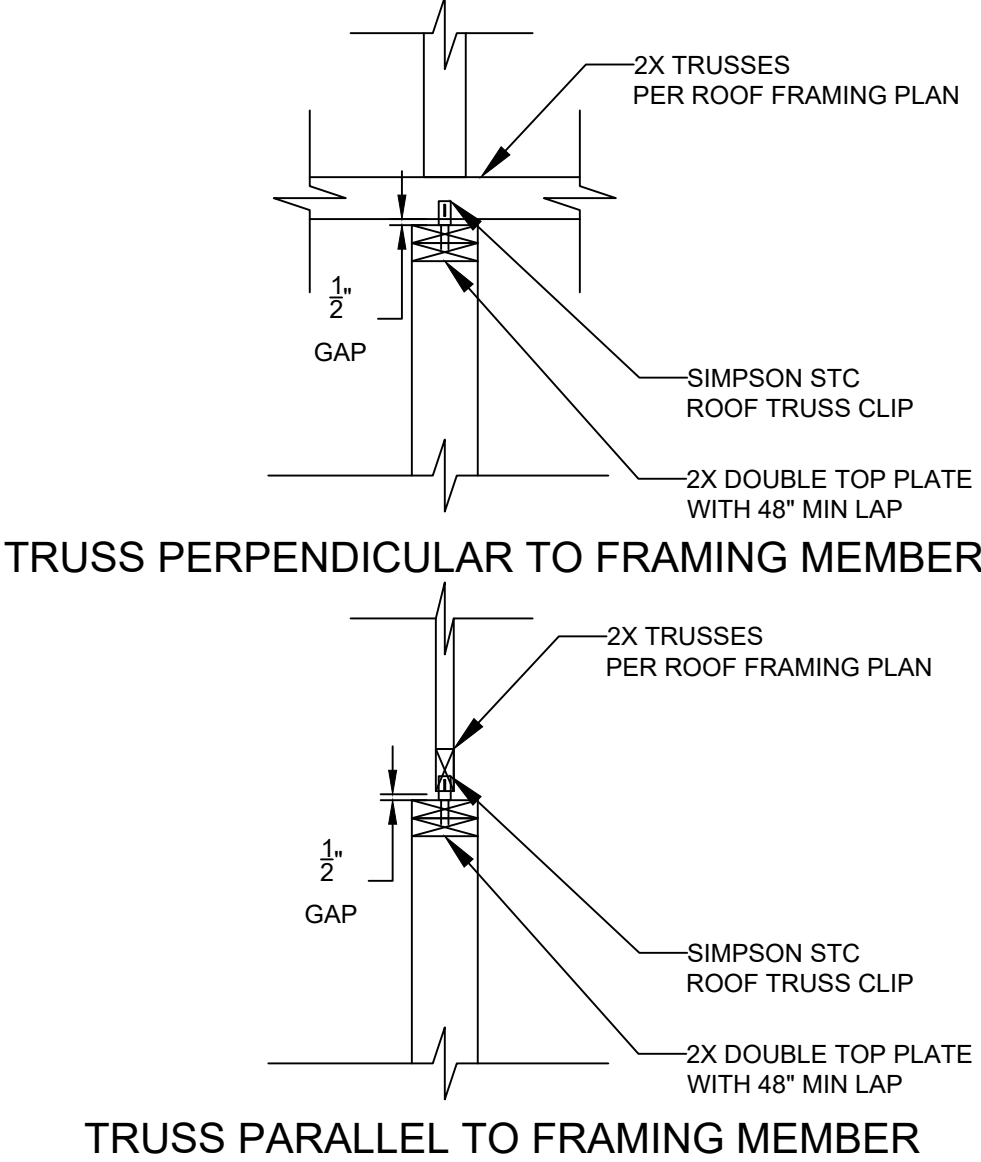


DETAIL 3
(NTS)

WOOD STRUCTURAL PANEL SHEATHING							
MARK	MINIMUM NAIL		MINIMUM WOOD STRUCTURAL PANEL SPAN RATING	MINIMUM NOMUNAL PANEL THICKNESS (in)	MAXIMUM WALL STUD SPACING (in)	PANEL NAIL SPACING	
	SIZE	PENETRATION (in)				EDGES (inches o/c)	FIELD (inches o/c)
1	6D COMMON	1.5	24:0	3/8"	16	6	12
	8D COMMON	1.75	24:16	7/16"	16	6	12

WOOD STRUCTURAL PANELS SHALL CONFORM TO DOC PS 1, DOC PS 2 OR ANSI/APA PRP 210, CSA O437 OR CSA O325. PANELS SHALL BE IDENTIFIED BY A GRADE MARK OR CERTIFICATE OF INSPECTION ISSUED BY AN APPROVED AGENCY

VERTICAL JOINTS OF PANEL SHEATHING SHALL OCCUR OVER AND BE FASTENED TO COMMON STUDS. HORIZONTAL JOINTS IN BRACED WALL PANELS SHALL OCCUR OVER AND BE FASTENED TO COMMON BLOCKING OF A MINIMUM 1 1/2 INCH THICKNESS.

LEGEND

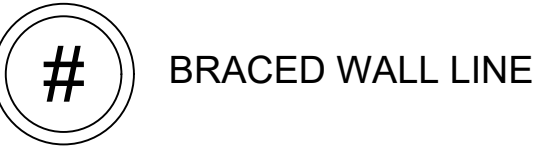

By using these pre-approved plans for accessory dwelling unit construction design, the user agrees to release, hold harmless, and indemnify the City of Tracy and its elected officials, employees, and agents, including the Architect who prepared these construction documents, from any and all claims, liabilities, suits, and demands on account of any injury, damage or loss to persons or property, including injury or death, or economic losses, arising out of the use of these construction documents. The use of these plans does not eliminate or reduce the user's responsibility to verify any and all information.

